


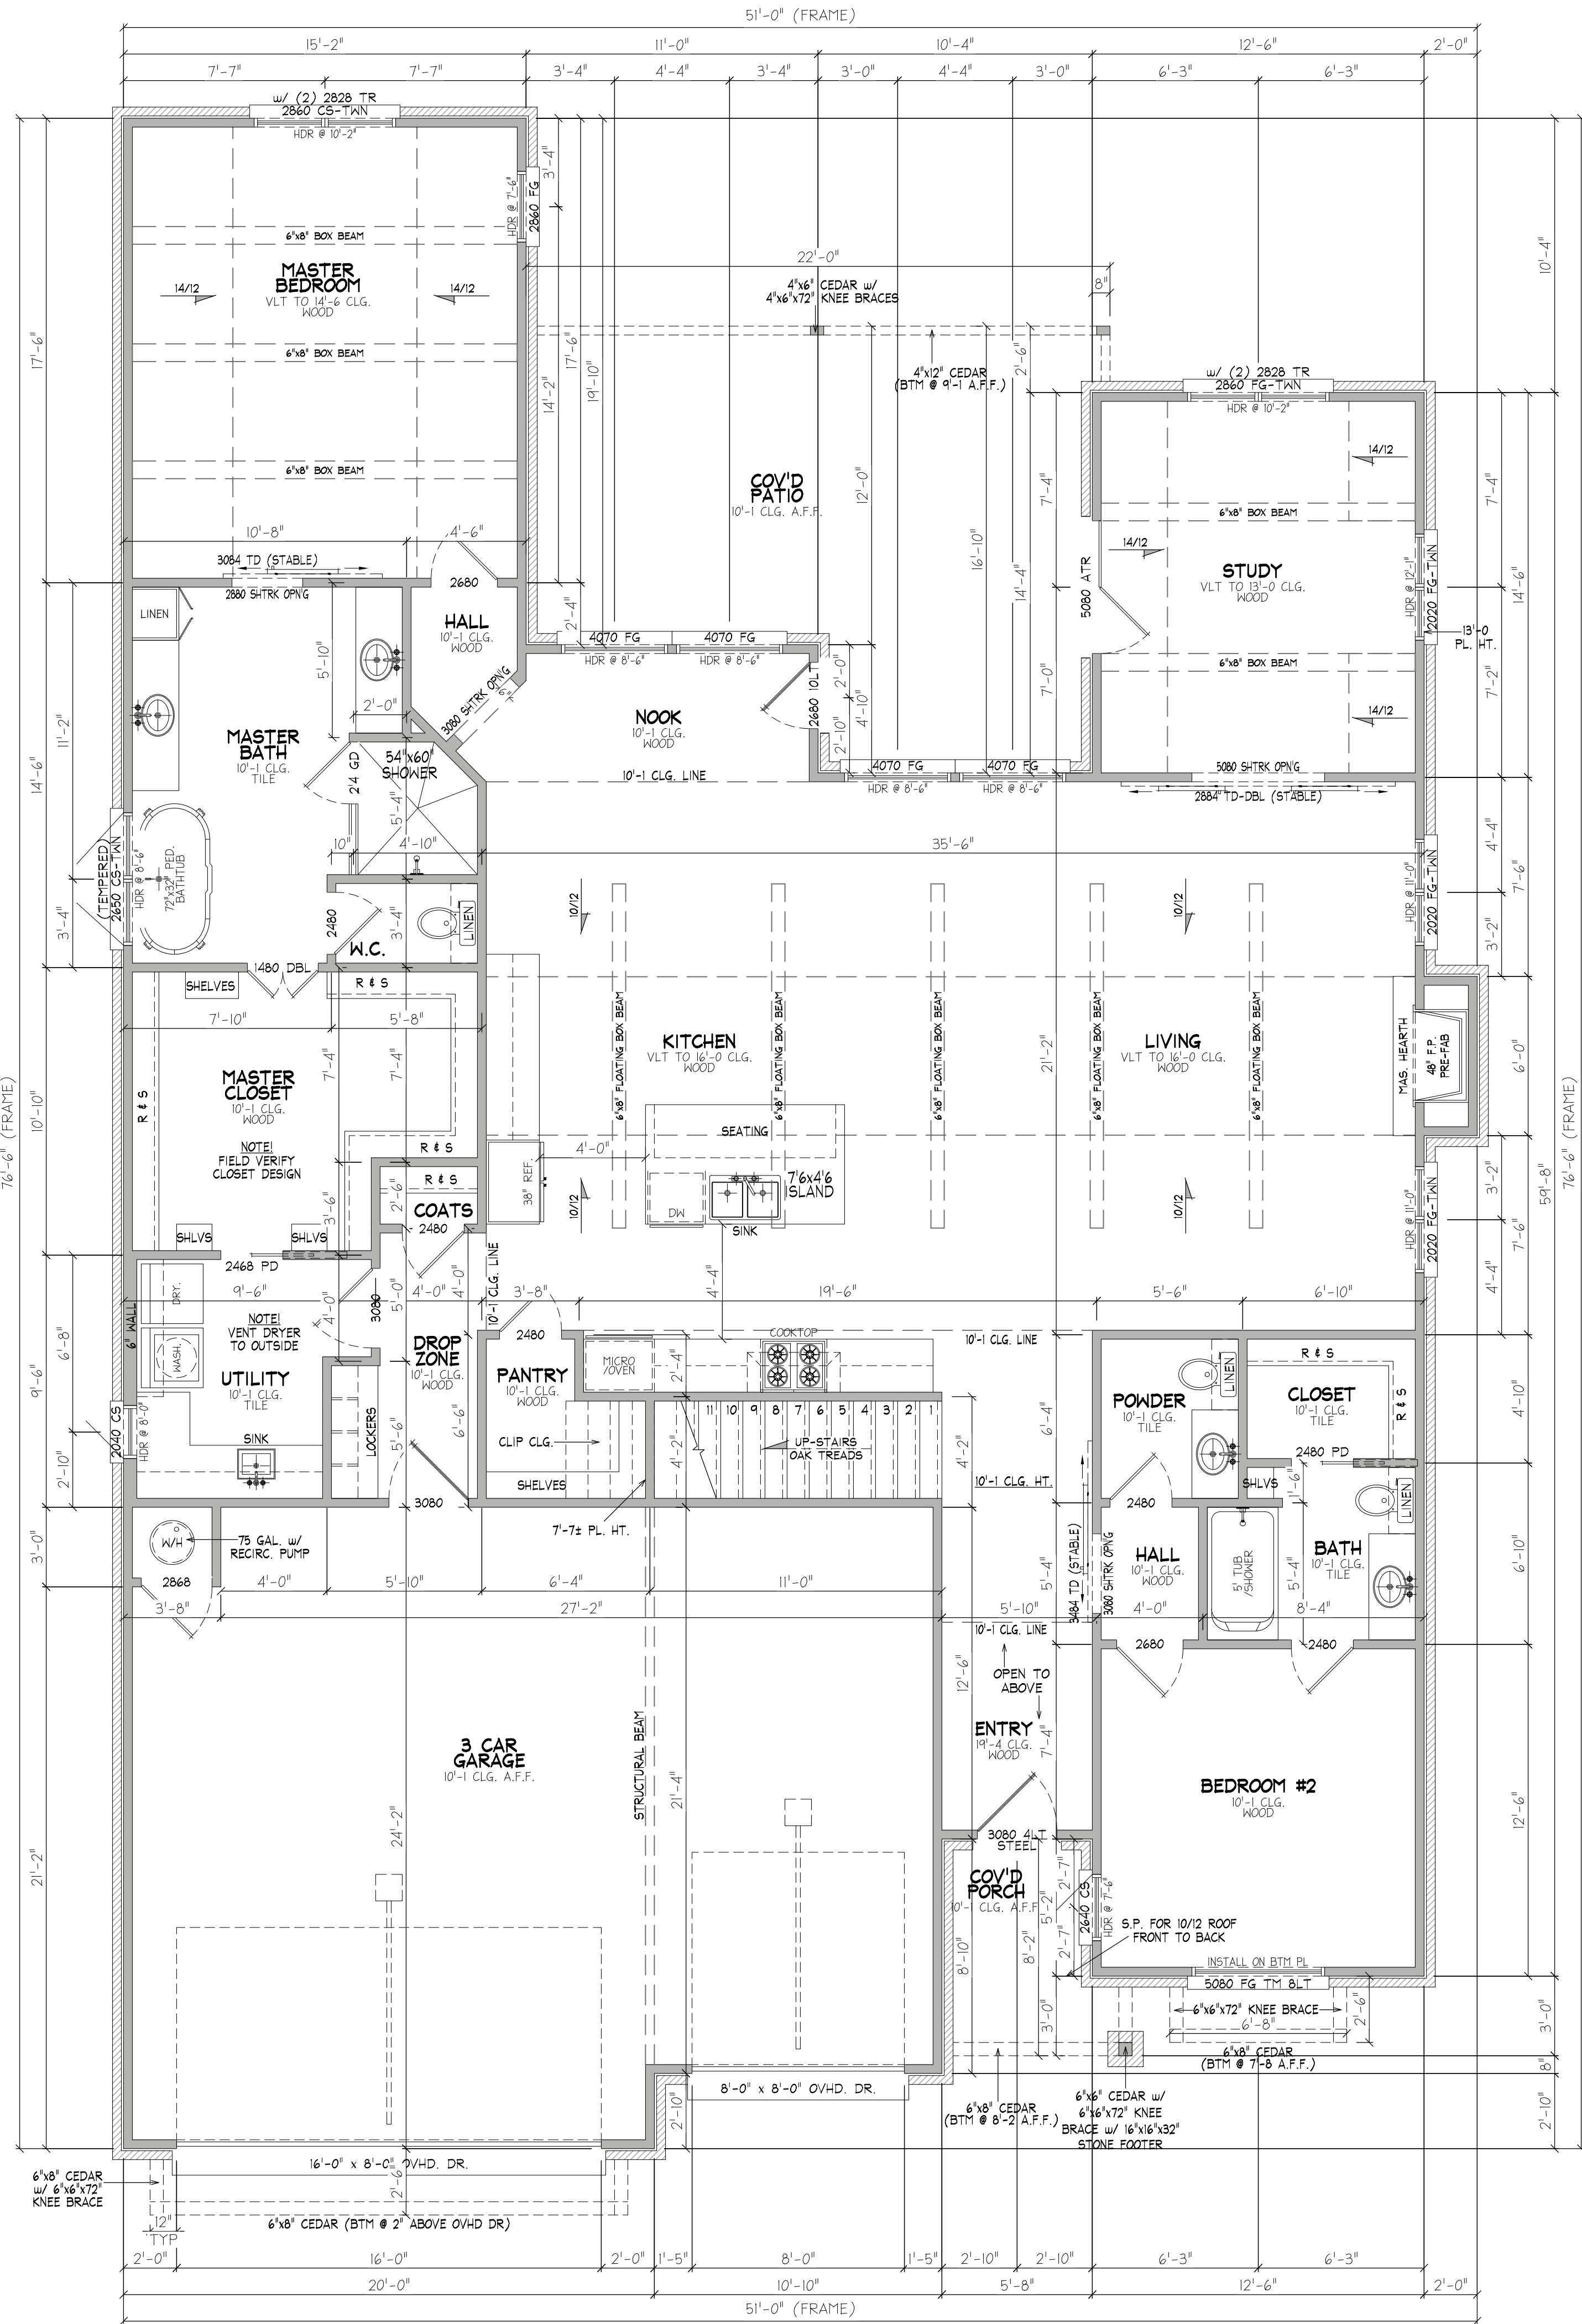


SCHEDULE NOTES

FIELD VERIFY EGRESS AND SAFETY
GLAZING AS REQUIRED BY CODE.

DOOR SCHEDULE					
MARK	QTY	SIZE	LOC.	REMARKS	
		WIDTH	HEIGHT		
818 O/H/D	1	8'-0"	8'-0"	EXT	OVERHEAD DOOR
1488 O/H/D	1	16'-0"	8'-0"	EXT	OVERHEAD DOOR
1480 DBL	1	2'-8"	8'-0"	INT	DOUBLE
214 GD	1	2'-0"	4'-0"	INT	GLASS SHOWER DOOR
2468	5	2'-4"	6'-8"	INT	
2480 PD	2	2'-4"	6'-8"	INT	POCKET DOOR,
2480	5	2'-4"	8'-0"	INT	
2480 PD	1	2'-4"	8'-0"	INT	POCKET DOOR,
2448	2	2'-6"	6'-8"	INT	
2680	2	2'-6"	8'-0"	INT	
2680 V/LT	1	2'-6"	8'-0"	EXT	10 LITE
2848	1	2'-8"	6'-8"	EXT	
2848	1	2'-8"	6'-8"	INT	
2884 TD-DBL	1	5'-4"	8'-4"	INT	TRACK DOOR, DOUBLE, STABLE
3080	1	3'-0"	8'-0"	EXT	
3080	1	3'-0"	8'-0"	INT	
3080 ALT STL	1	3'-0"	8'-0"	EXT	4 LITE, STEEL
3084 TD	1	3'-0"	8'-4"	INT	TRACK DOOR, STABLE
3484 TD	1	3'-4"	8'-4"	INT	TRACK DOOR, STABLE
5080 ATR	1	5'-0"	8'-0"	EXT	ATR

WINDOW SCHEDULE					
MARK	QTY	SIZE	HEIGHT	REMARKS	
		WIDTH	HEIGHT		
2020 FG-TWIN	3	4'-0"	2'-0"	FIXED	TWIN
2040 CS	2	2'-0"	4'-0"	CASEMENT	
2640 CS	1	2'-6"	4'-0"	CASEMENT	
2640 CS-TRP	1	7'-6"	4'-0"	CASEMENT	TRIPLE
2650 CS-TWIN	2	5'-0"	5'-0"	CASEMENT	TWIN
2650 CS-TWIN TH	1	5'-0"	5'-0"	CASEMENT	TWIN, TEMPERED
2650 FG	1	5'-0"	5'-0"	FIXED	
2628 TR	4	2'-6"	2'-8"	TRANSOM	FIXED
2840 CS-TWIN TR	1	5'-4"	6'-0"	CASEMENT	TWIN, w/ (2) 2828 TR
2840 FG-TWIN TR	1	5'-4"	6'-0"	FIXED	TWIN, w/ (2) 2828 TR
2840 FG	1	2'-8"	6'-0"	FIXED	
3036 FG 4 LT	1	3'-0"	3'-6"	FIXED	4 LITE
4070 FG	4	4'-0"	7'-0"	FIXED	CLEARVIEW
5080 FG TH BLT	1	5'-0"	8'-0"	FIXED	TEMPERED, 8 LITE

NOTE:
9'-1 CLG. HT. LOWER LEVEL UNLESS NOTED.

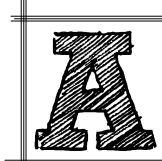

Lower Level Floor Plan

Scale: 1/4" = 1'-0"

THIS DRAWING IS A CONCEPT. IT INDICATES THE GENERAL LAYOUT OF THE PROPOSED WORK. IT DOES NOT CONSTITUTE A CONTRACT. THE CONTRACTOR SHALL BE RESPONSIBLE FOR OBTAINING ALL NECESSARY PERMITS AND FOR VERIFYING THE ACCURACY OF THE INFORMATION PROVIDED. THE CONTRACTOR SHALL BE RESPONSIBLE FOR OBTAINING ALL NECESSARY PERMITS AND FOR VERIFYING THE ACCURACY OF THE INFORMATION PROVIDED. THE CONTRACTOR SHALL BE RESPONSIBLE FOR OBTAINING ALL NECESSARY PERMITS AND FOR VERIFYING THE ACCURACY OF THE INFORMATION PROVIDED.

COZORT
CONSTRUCTION

Project Name:


Location:
Project #: 22.06.03

First: 2270
Second: 1192
Total Living: 3462
Total Veneer: 3598
Garage: 710
Covid Porch: 358

Date: 4/21/2022


DRAWING #

A1

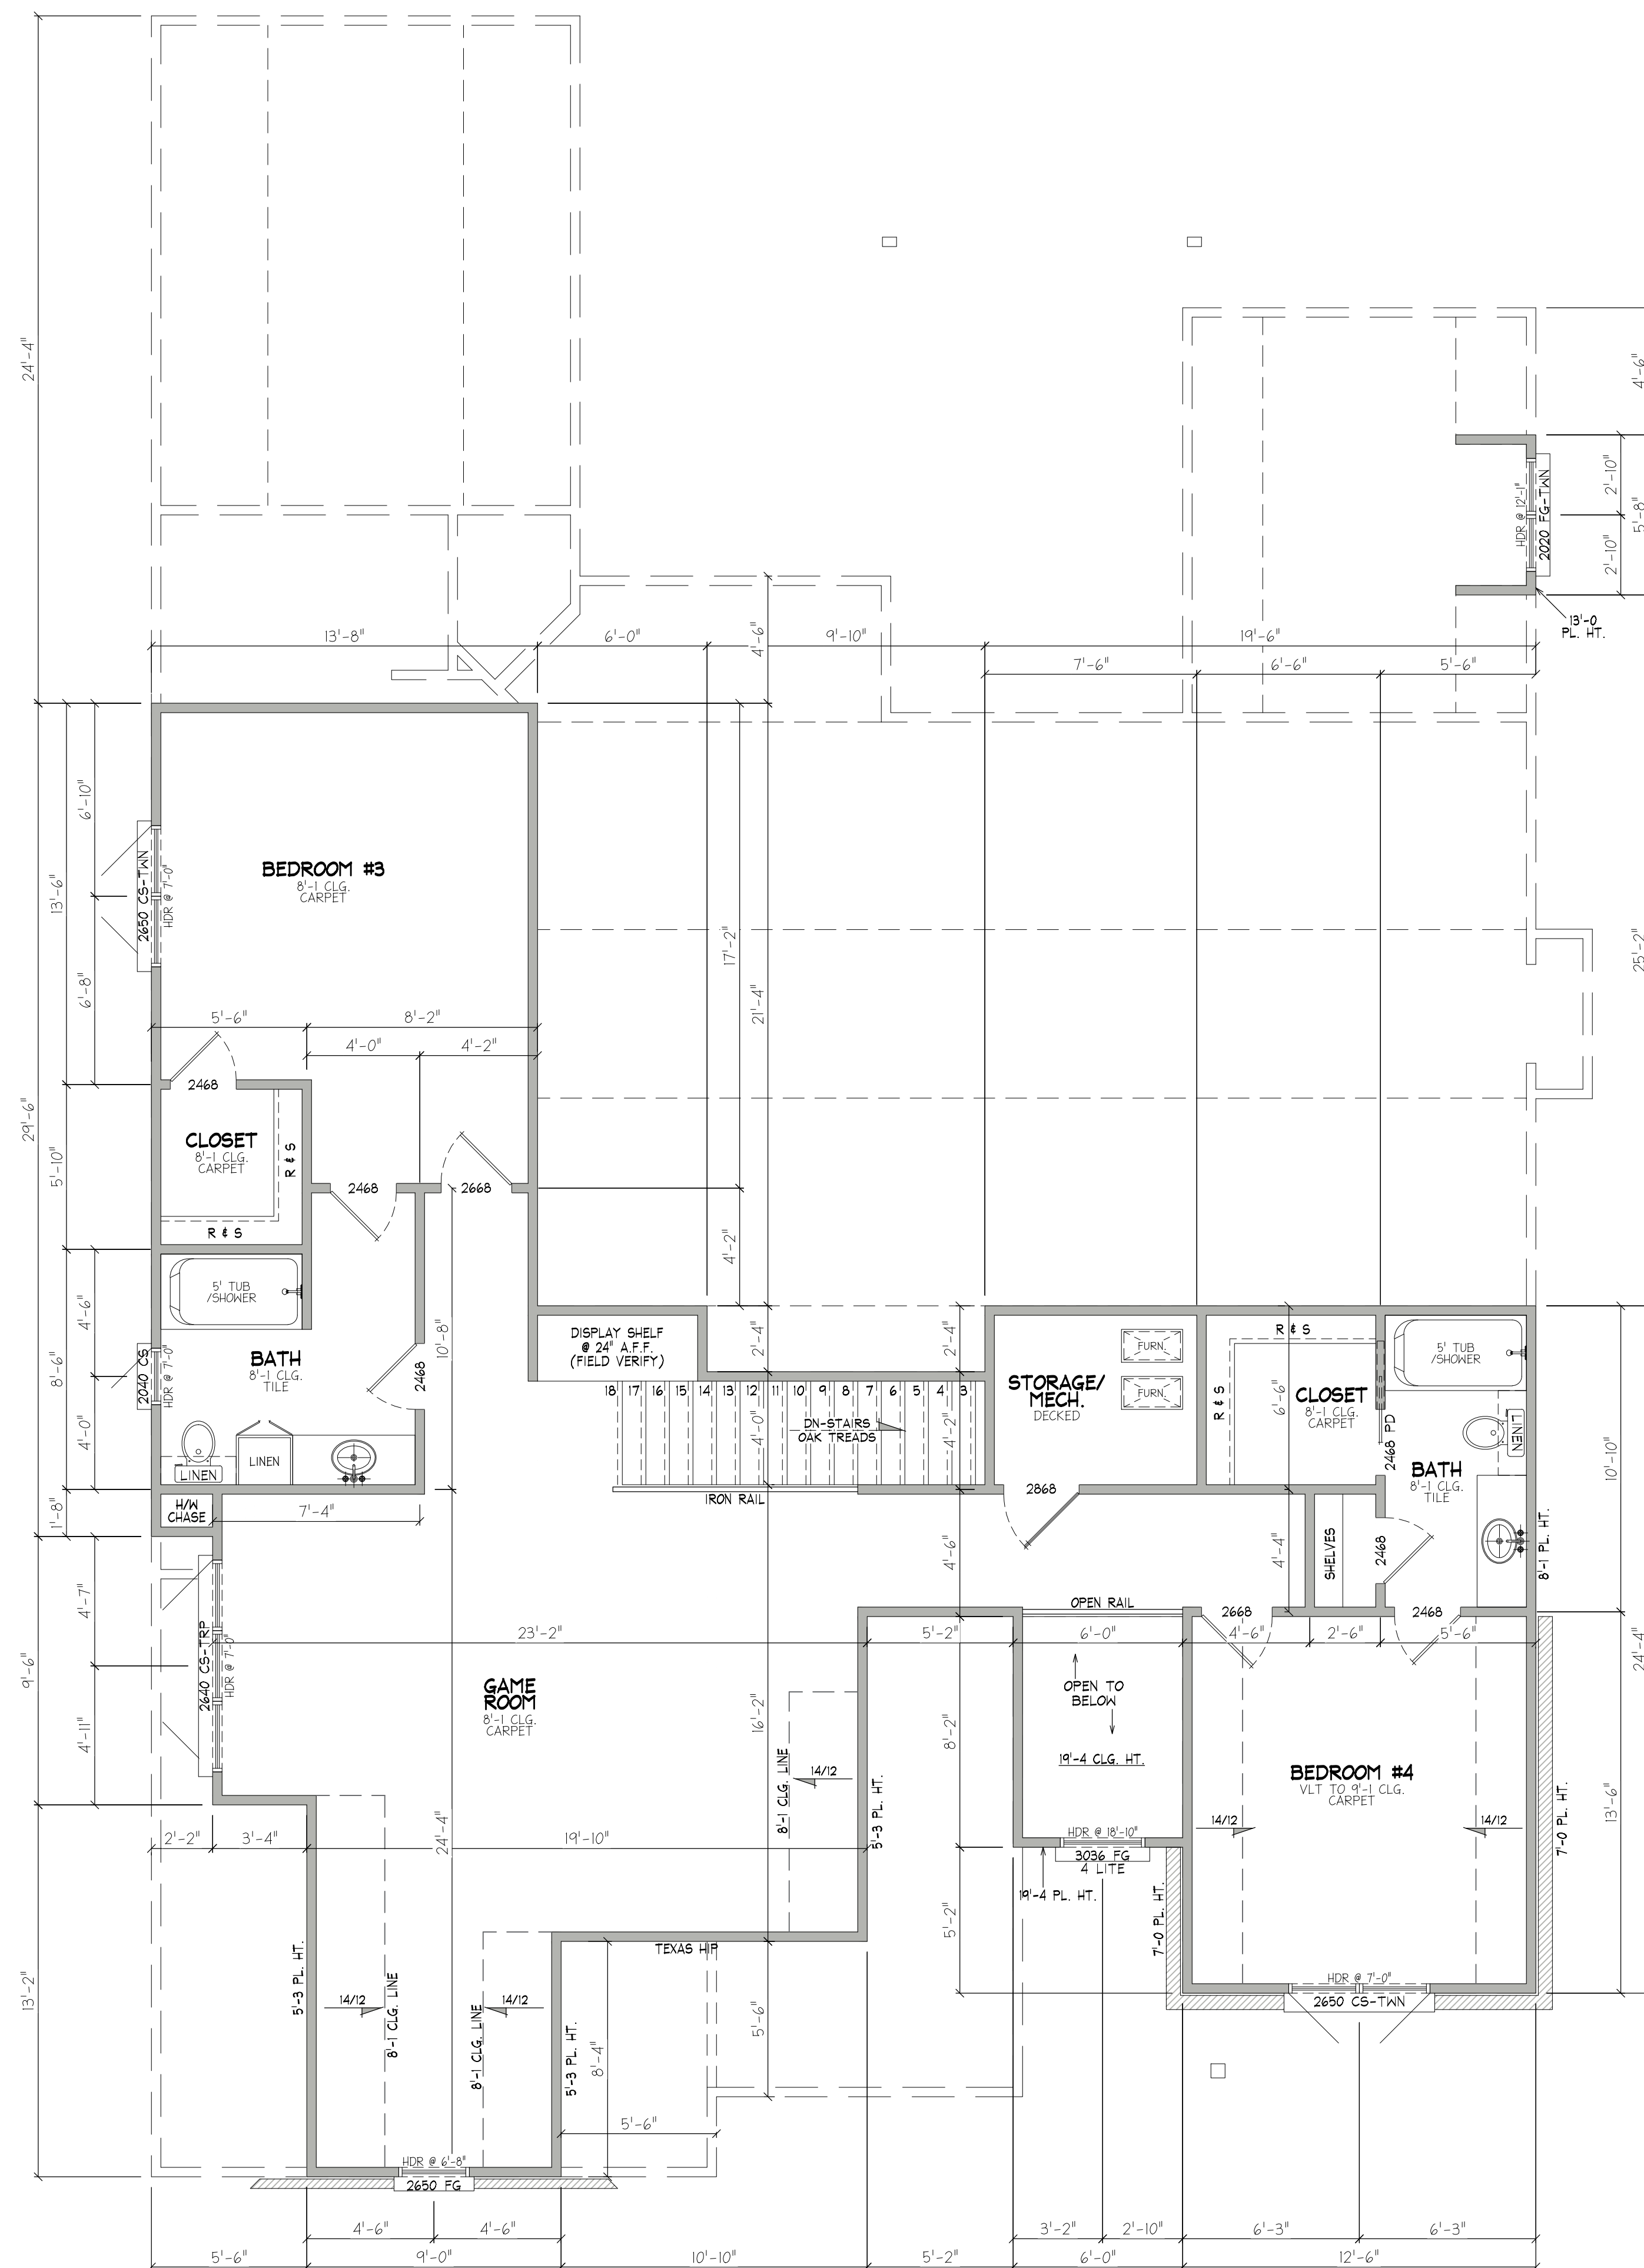


NOTE!
8¹-1 PL. HT. UPPER LEVEL UNLESS NOTED.




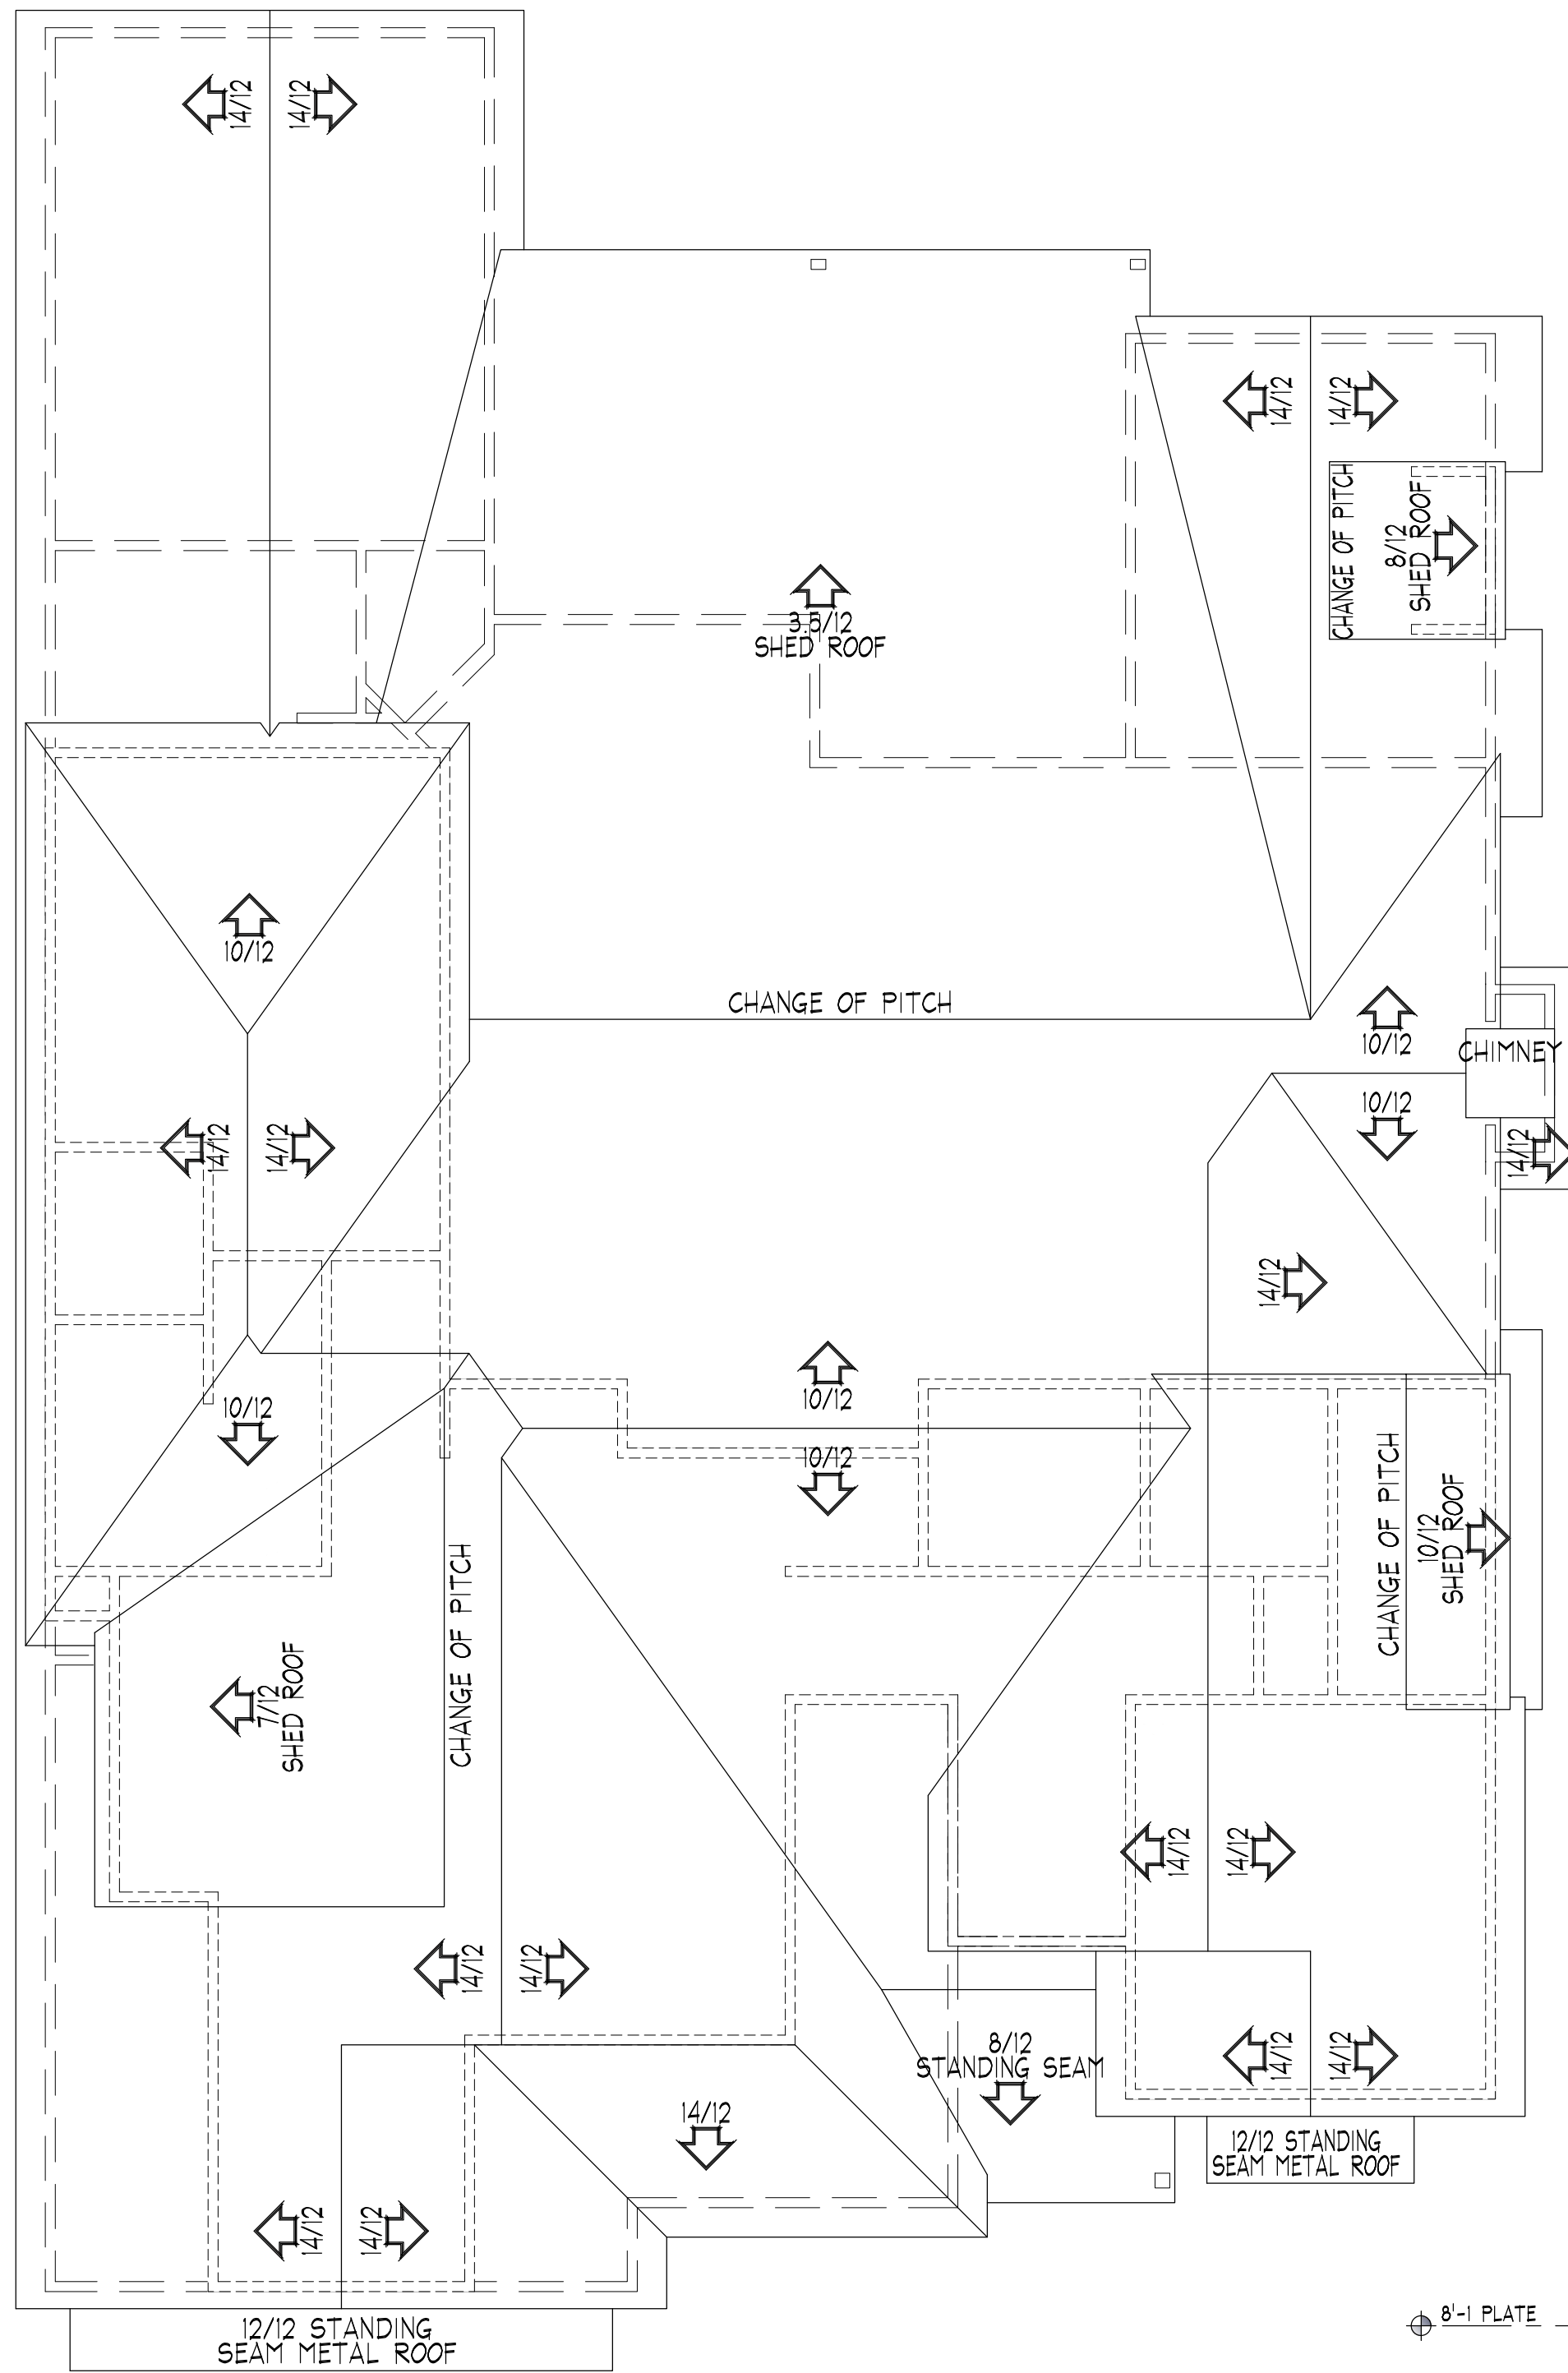


C Roof Plan
Scale: 3/16" = 1'-0"

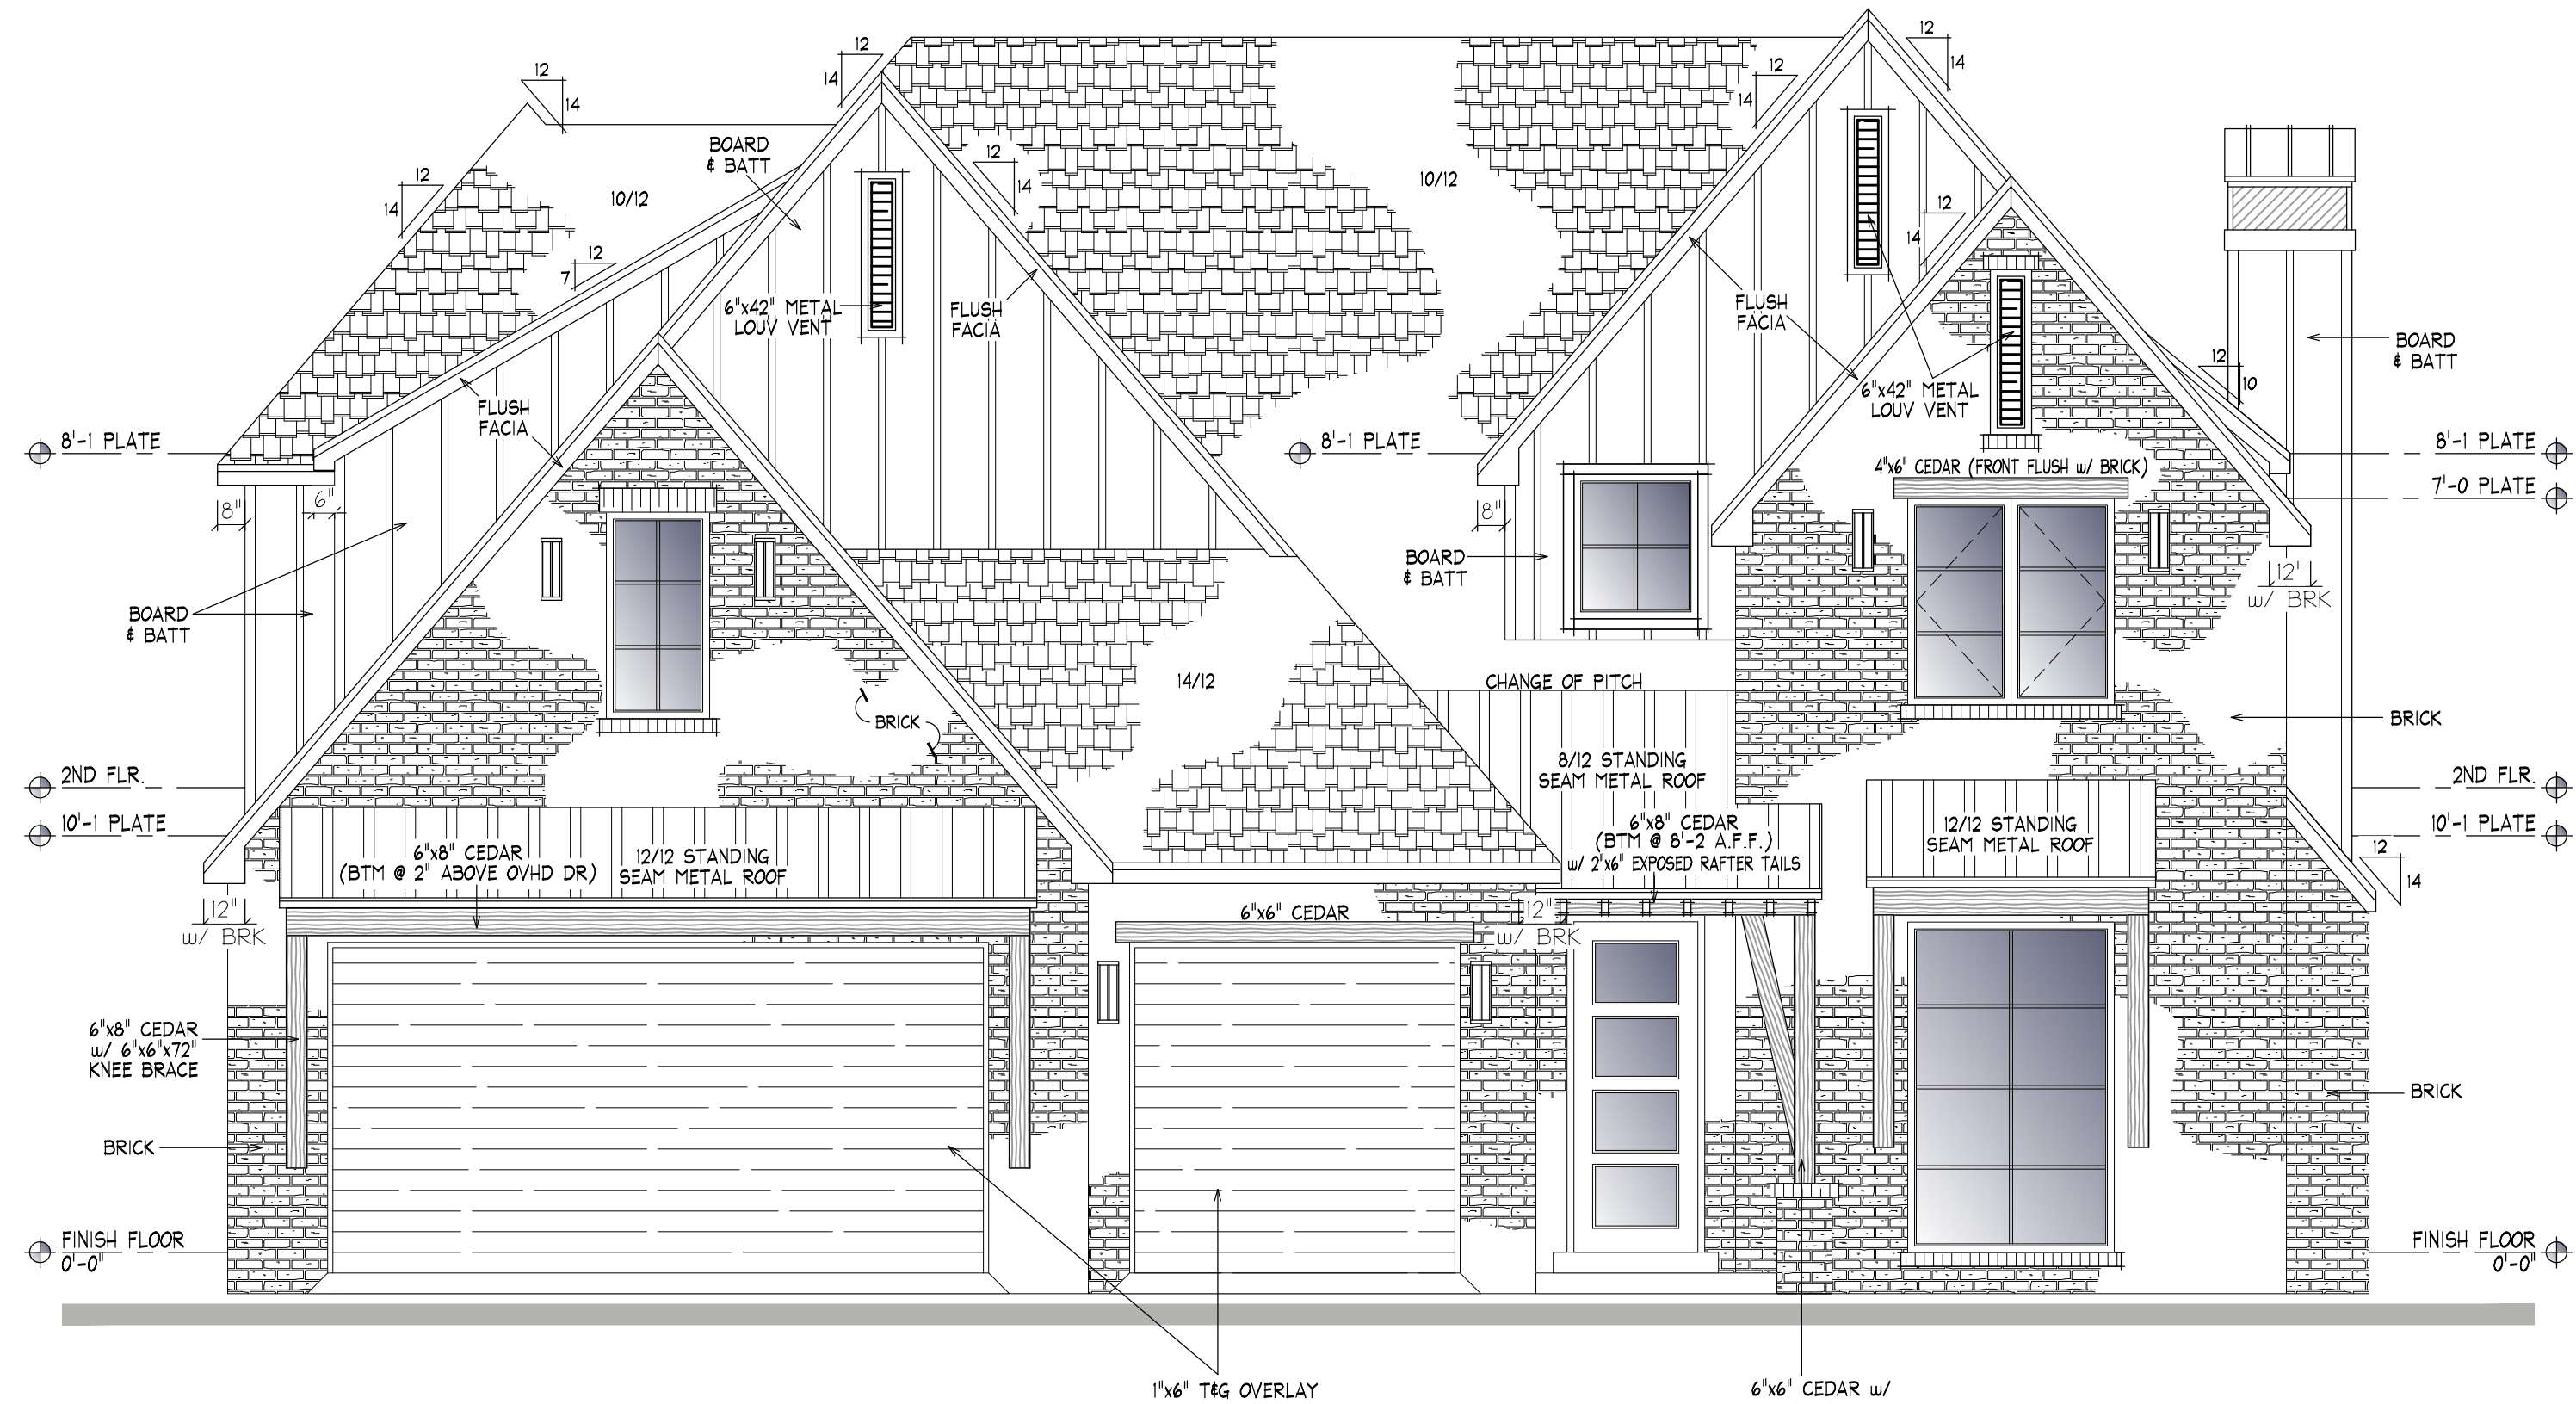


A Front Elevation
Scale: 1/4" = 1'-0"

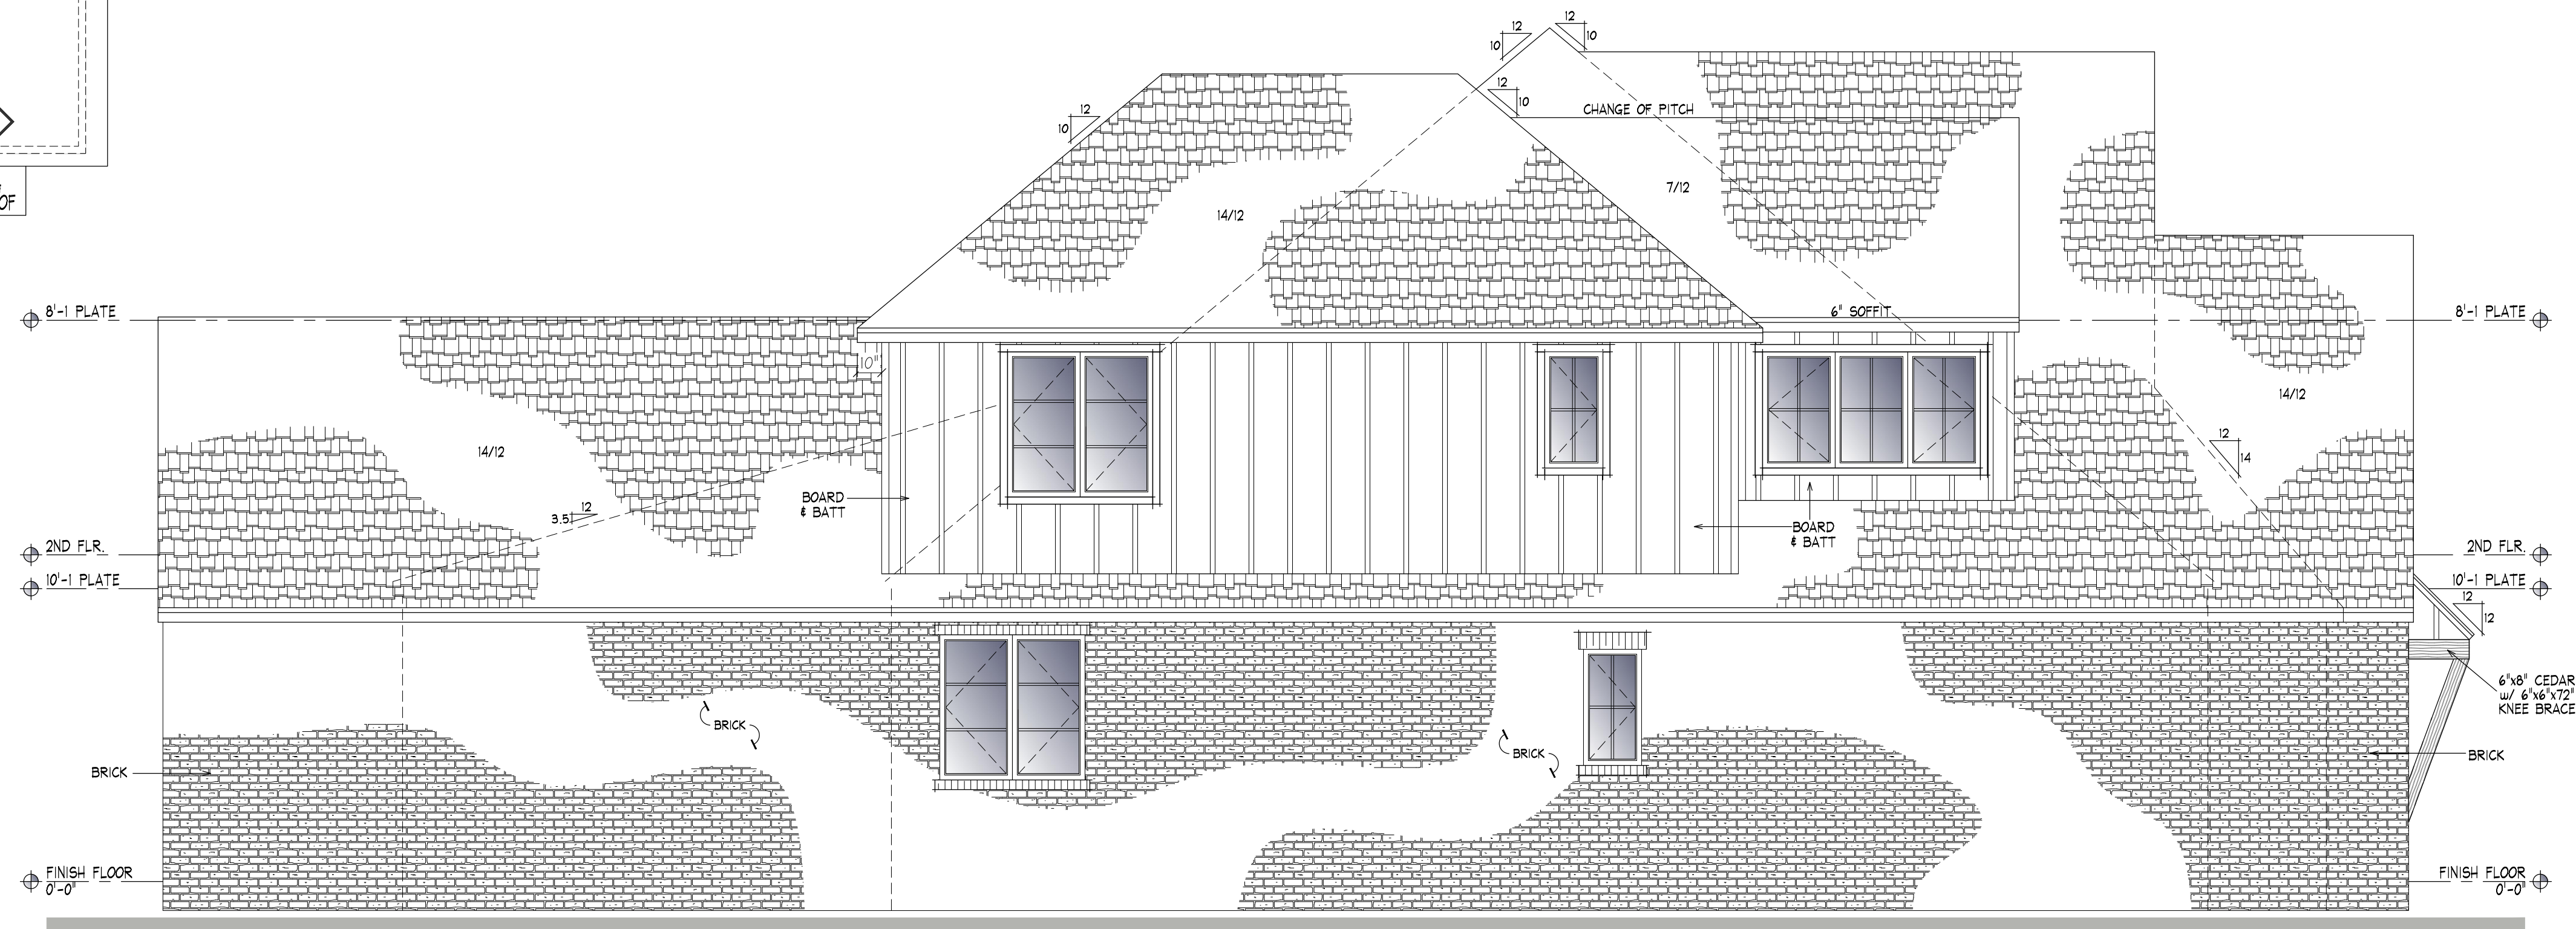

B Left Side
Scale: 1/4" = 1'-0"

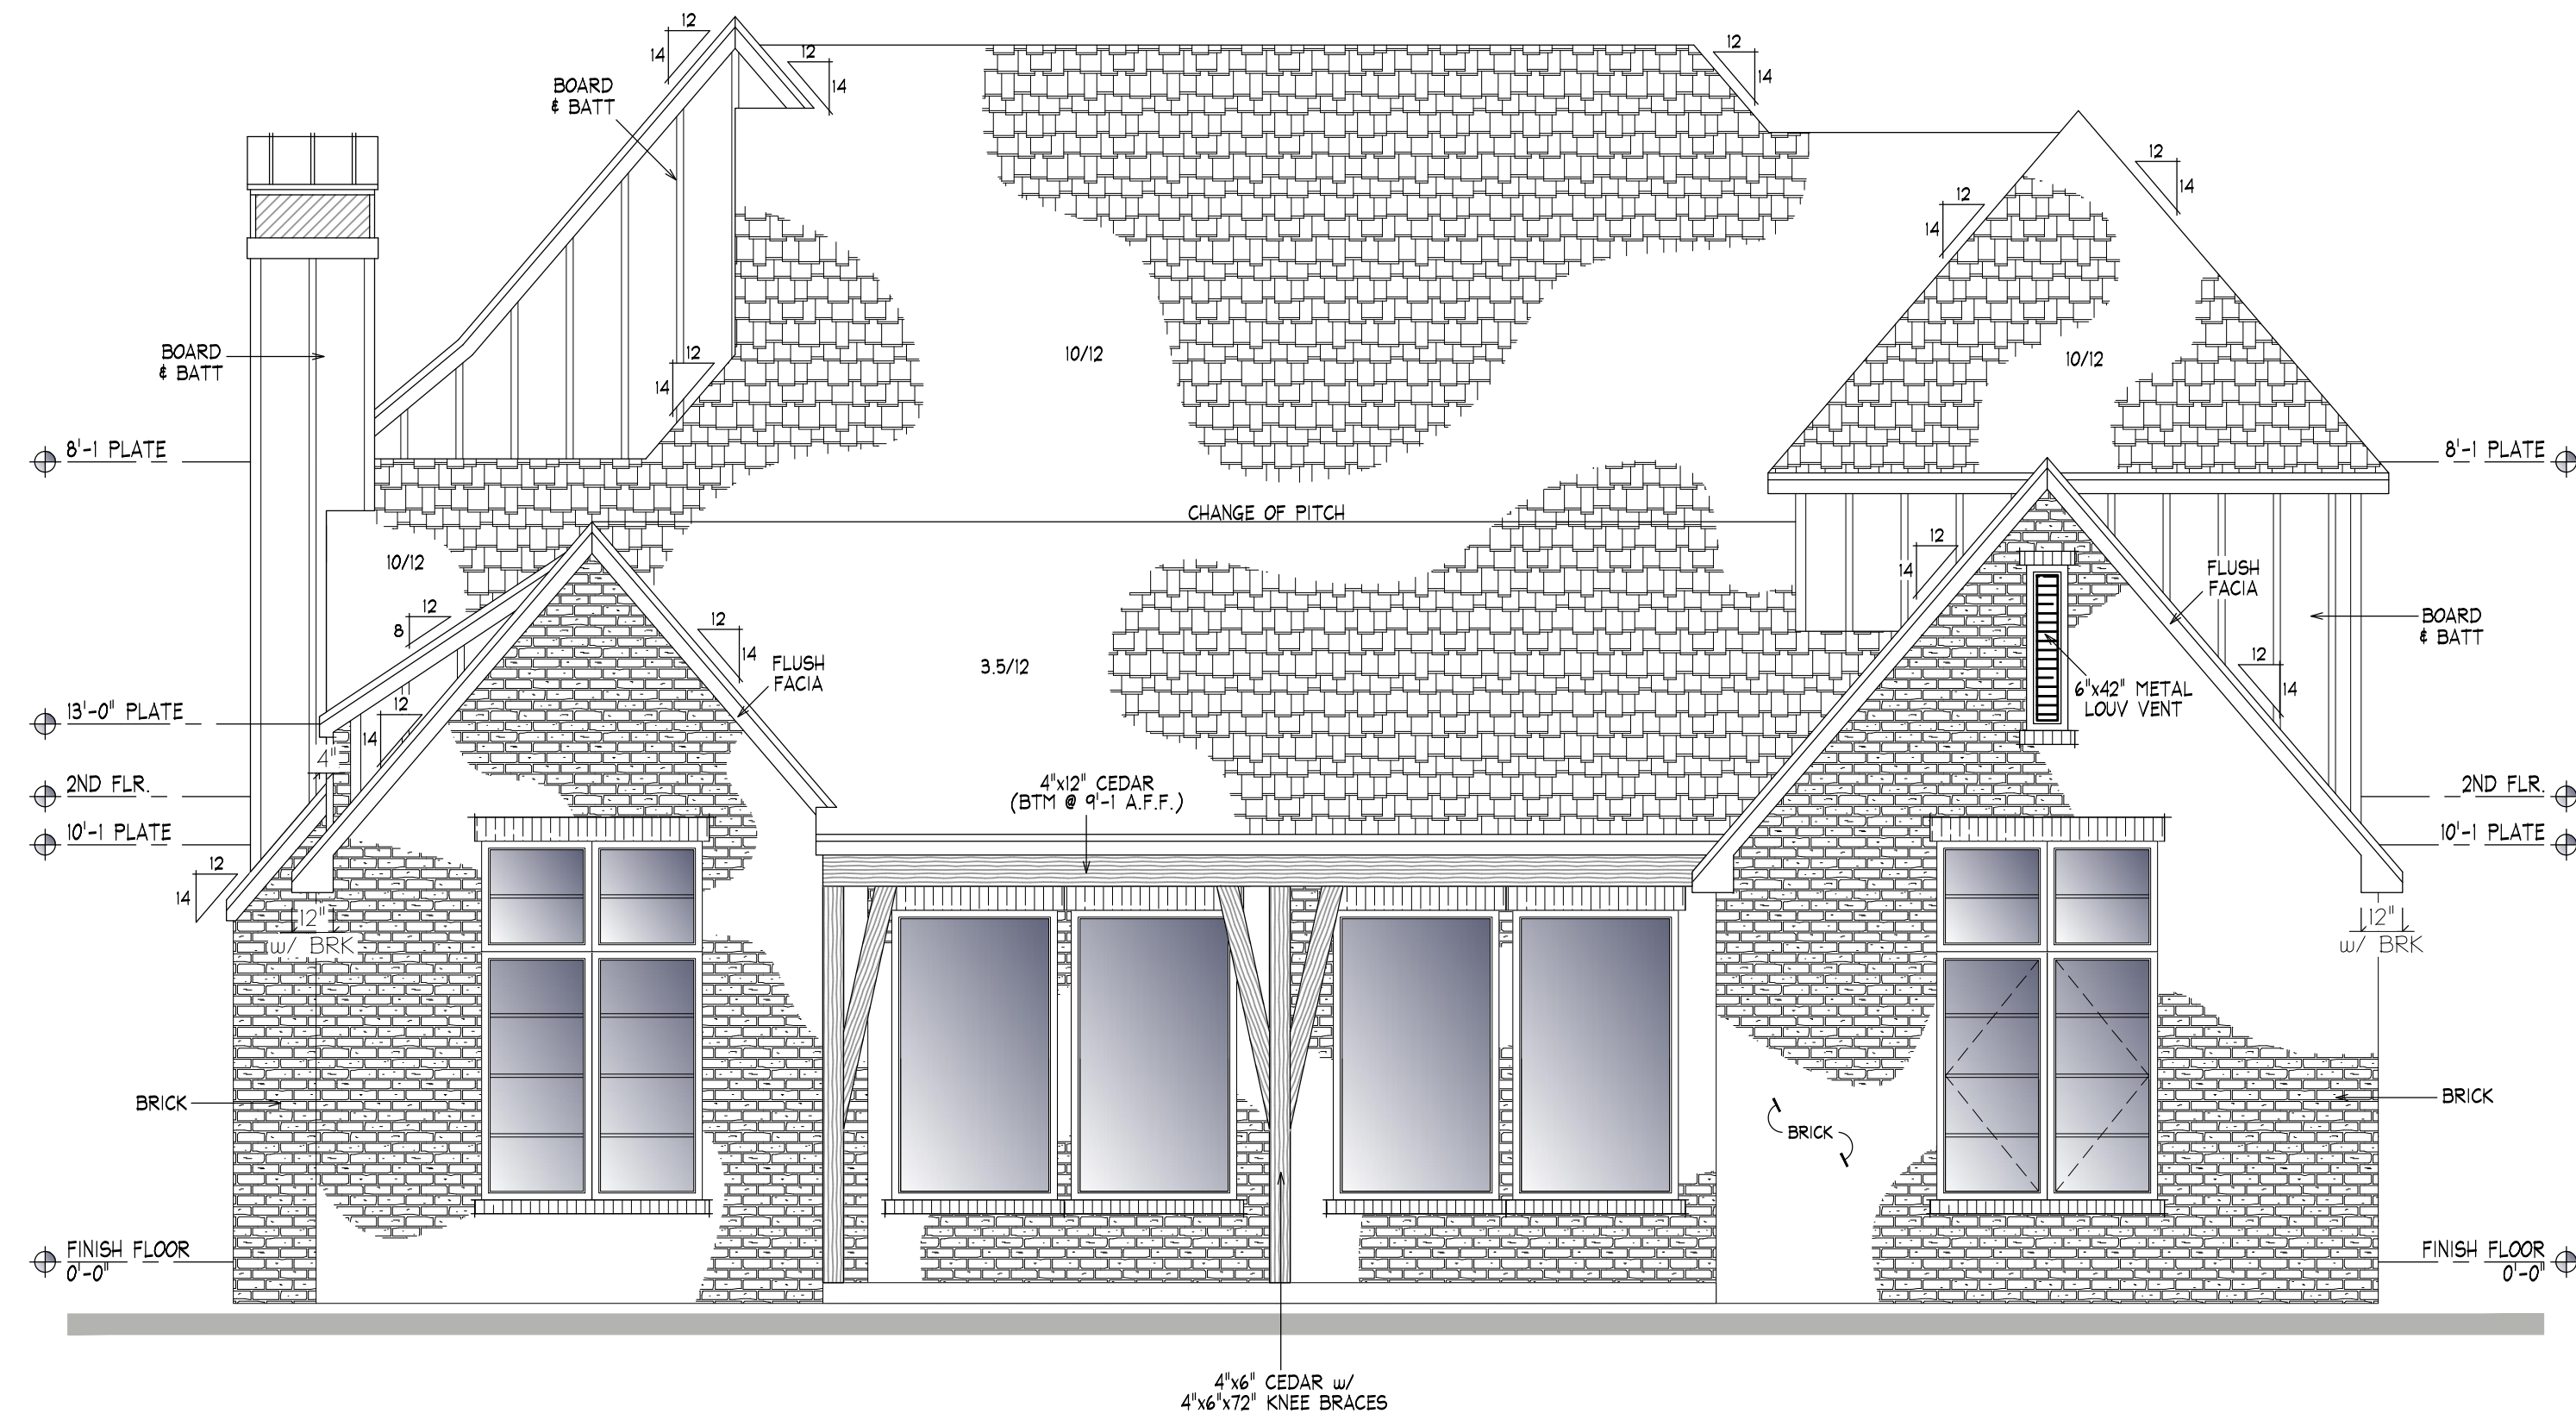

A Rear Elevation
Scale: 1/4" = 1'-0"

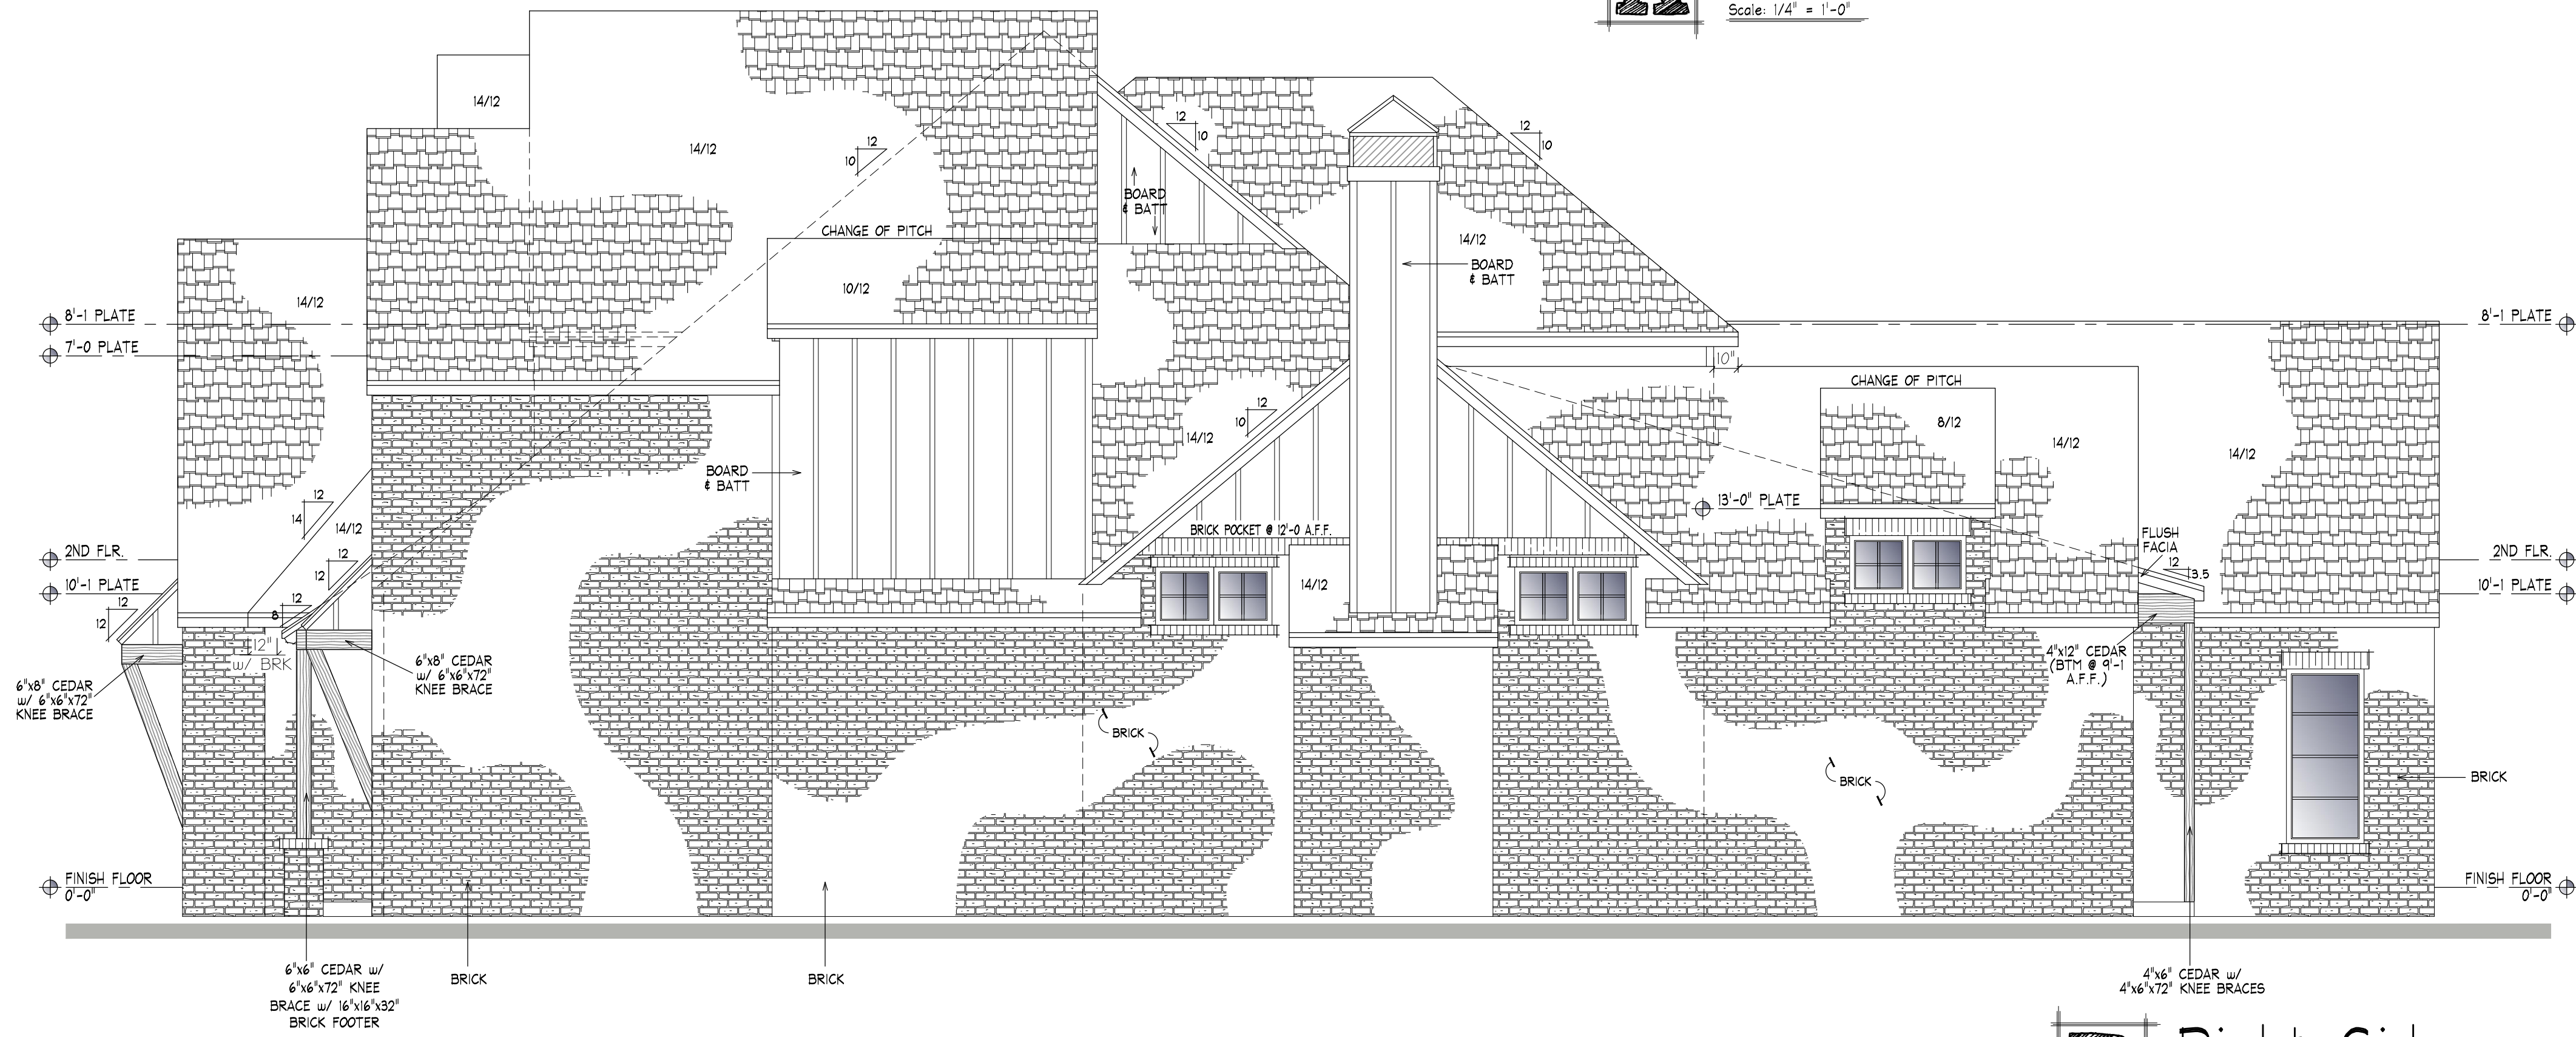

B Right Side
Scale: 1/4" = 1'-0"

THIS DRAWING IS A CONCEPT. IT INDICATES THE GENERAL LAYOUT OF THE PROPOSED WORK. IT DOES NOT GUARANTEE THE COMPLETION OF THE WORK. THE CONTRACTOR IS RESPONSIBLE FOR OBTAINING ALL NECESSARY PERMITS AND FOR VERIFYING THE ACCURACY OF THE INFORMATION PROVIDED. THE CONTRACTOR SHALL BE RESPONSIBLE FOR OBTAINING ALL NECESSARY PERMITS AND FOR VERIFYING THE ACCURACY OF THE INFORMATION PROVIDED. THE CONTRACTOR SHALL BE RESPONSIBLE FOR OBTAINING ALL NECESSARY PERMITS AND FOR VERIFYING THE ACCURACY OF THE INFORMATION PROVIDED.


COZORT
CONSTRUCTION

Project Name:	
Location:	
Project #:	22.06.03

First:	2270
Second:	1192
Total Living:	3462
Total Veneer:	3598
Garage:	710
Cov'd Porch:	358

Date: 4/21/2022


DRAWING #
A4

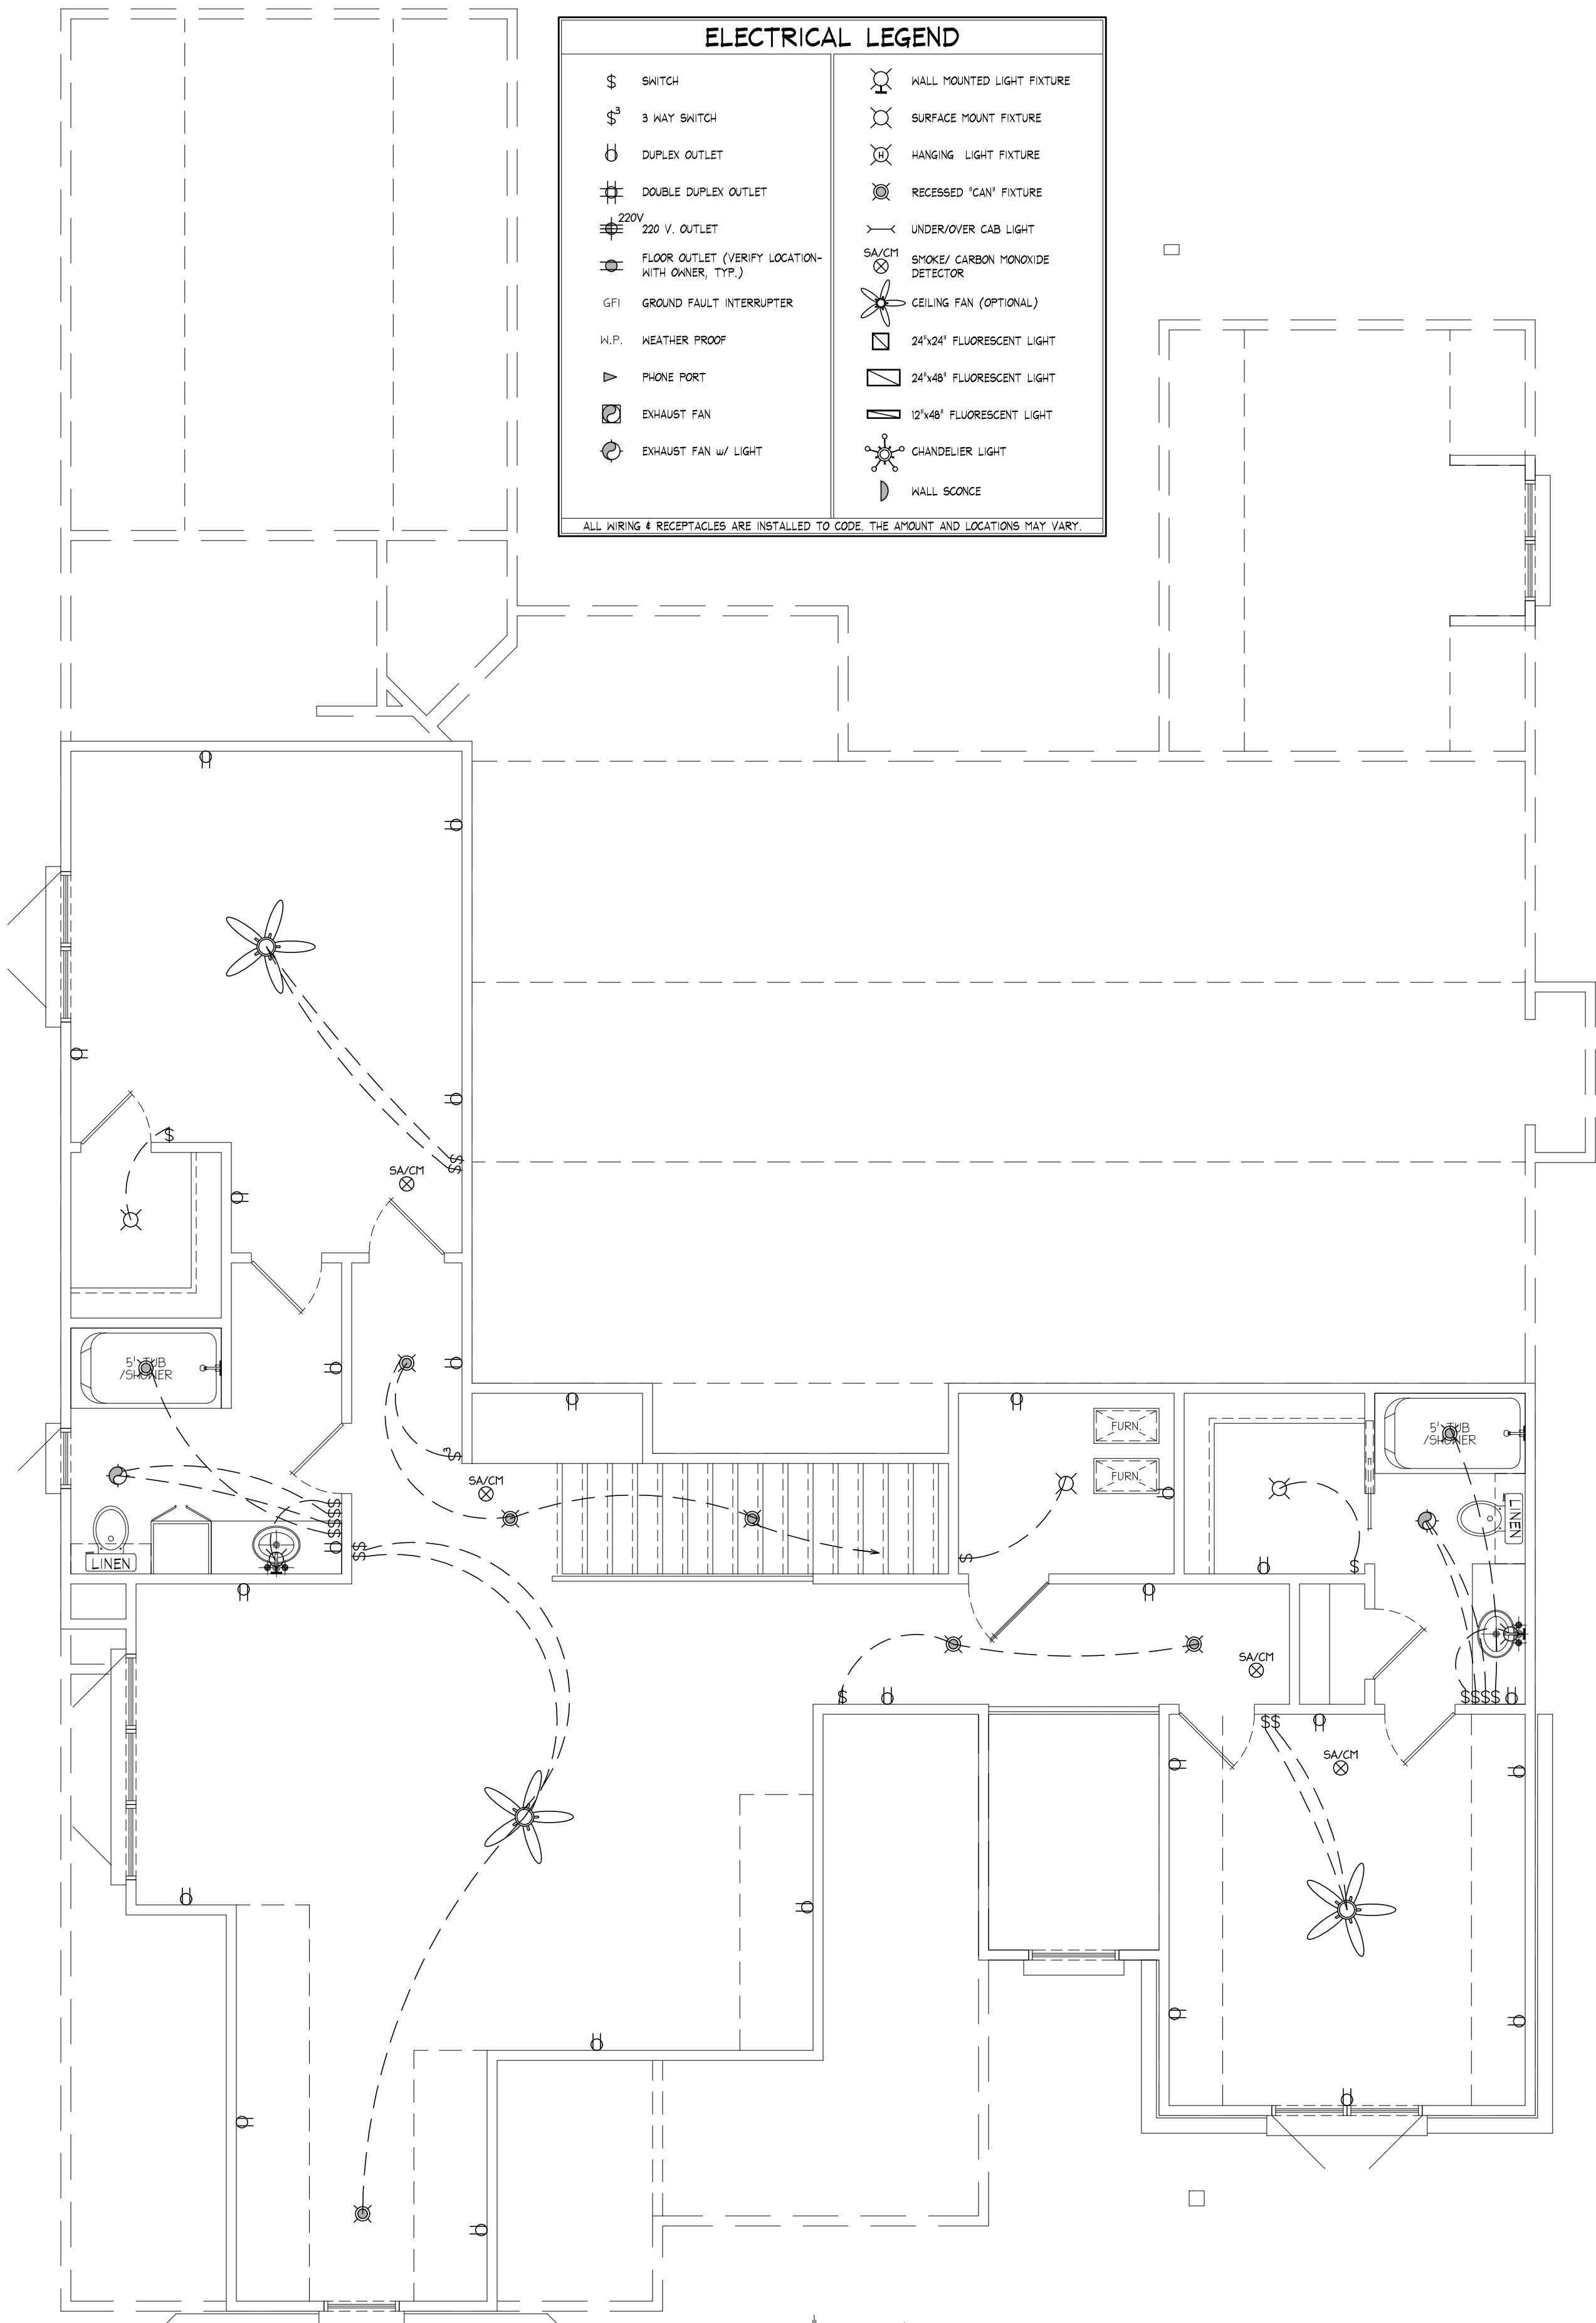

ELECTRICAL LEGEND	
\$	SWITCH
\$3	3 WAY SWITCH
□	DUPLEX OUTLET
⊕	DOUBLE DUPLEX OUTLET
220V	220 V. OUTLET
⊕	FLOOR OUTLET (VERIFY LOCATION WITH OWNER, TYP.)
GFI	GROUND FAULT INTERRUPTER
H.P.	HEATHER PROOF
▽	PHONE PORT
⊕	EXHAUST FAN
⊕	EXHAUST FAN w/ LIGHT
⊕	WALL MOUNTED LIGHT FIXTURE
⊕	SURFACE MOUNT FIXTURE
⊕	HANGING LIGHT FIXTURE
⊕	RECESSED "CAN" FIXTURE
⊕	UNDER/OVER CAB LIGHT
SA/CH	SMOKE/ CARBON MONOXIDE DETECTOR
⊕	CEILING FAN (OPTIONAL)
⊕	24"X24" FLUORESCENT LIGHT
⊕	24"X48" FLUORESCENT LIGHT
⊕	12"X48" FLUORESCENT LIGHT
⊕	CHANDELLER LIGHT
⊕	WALL SCONCE

ALL WIRING & RECEPTACLES ARE INSTALLED TO CODE. THE AMOUNT AND LOCATIONS MAY VARY.

B Upper Level Electrical Plan
Scale: 3/16" = 1'-0"

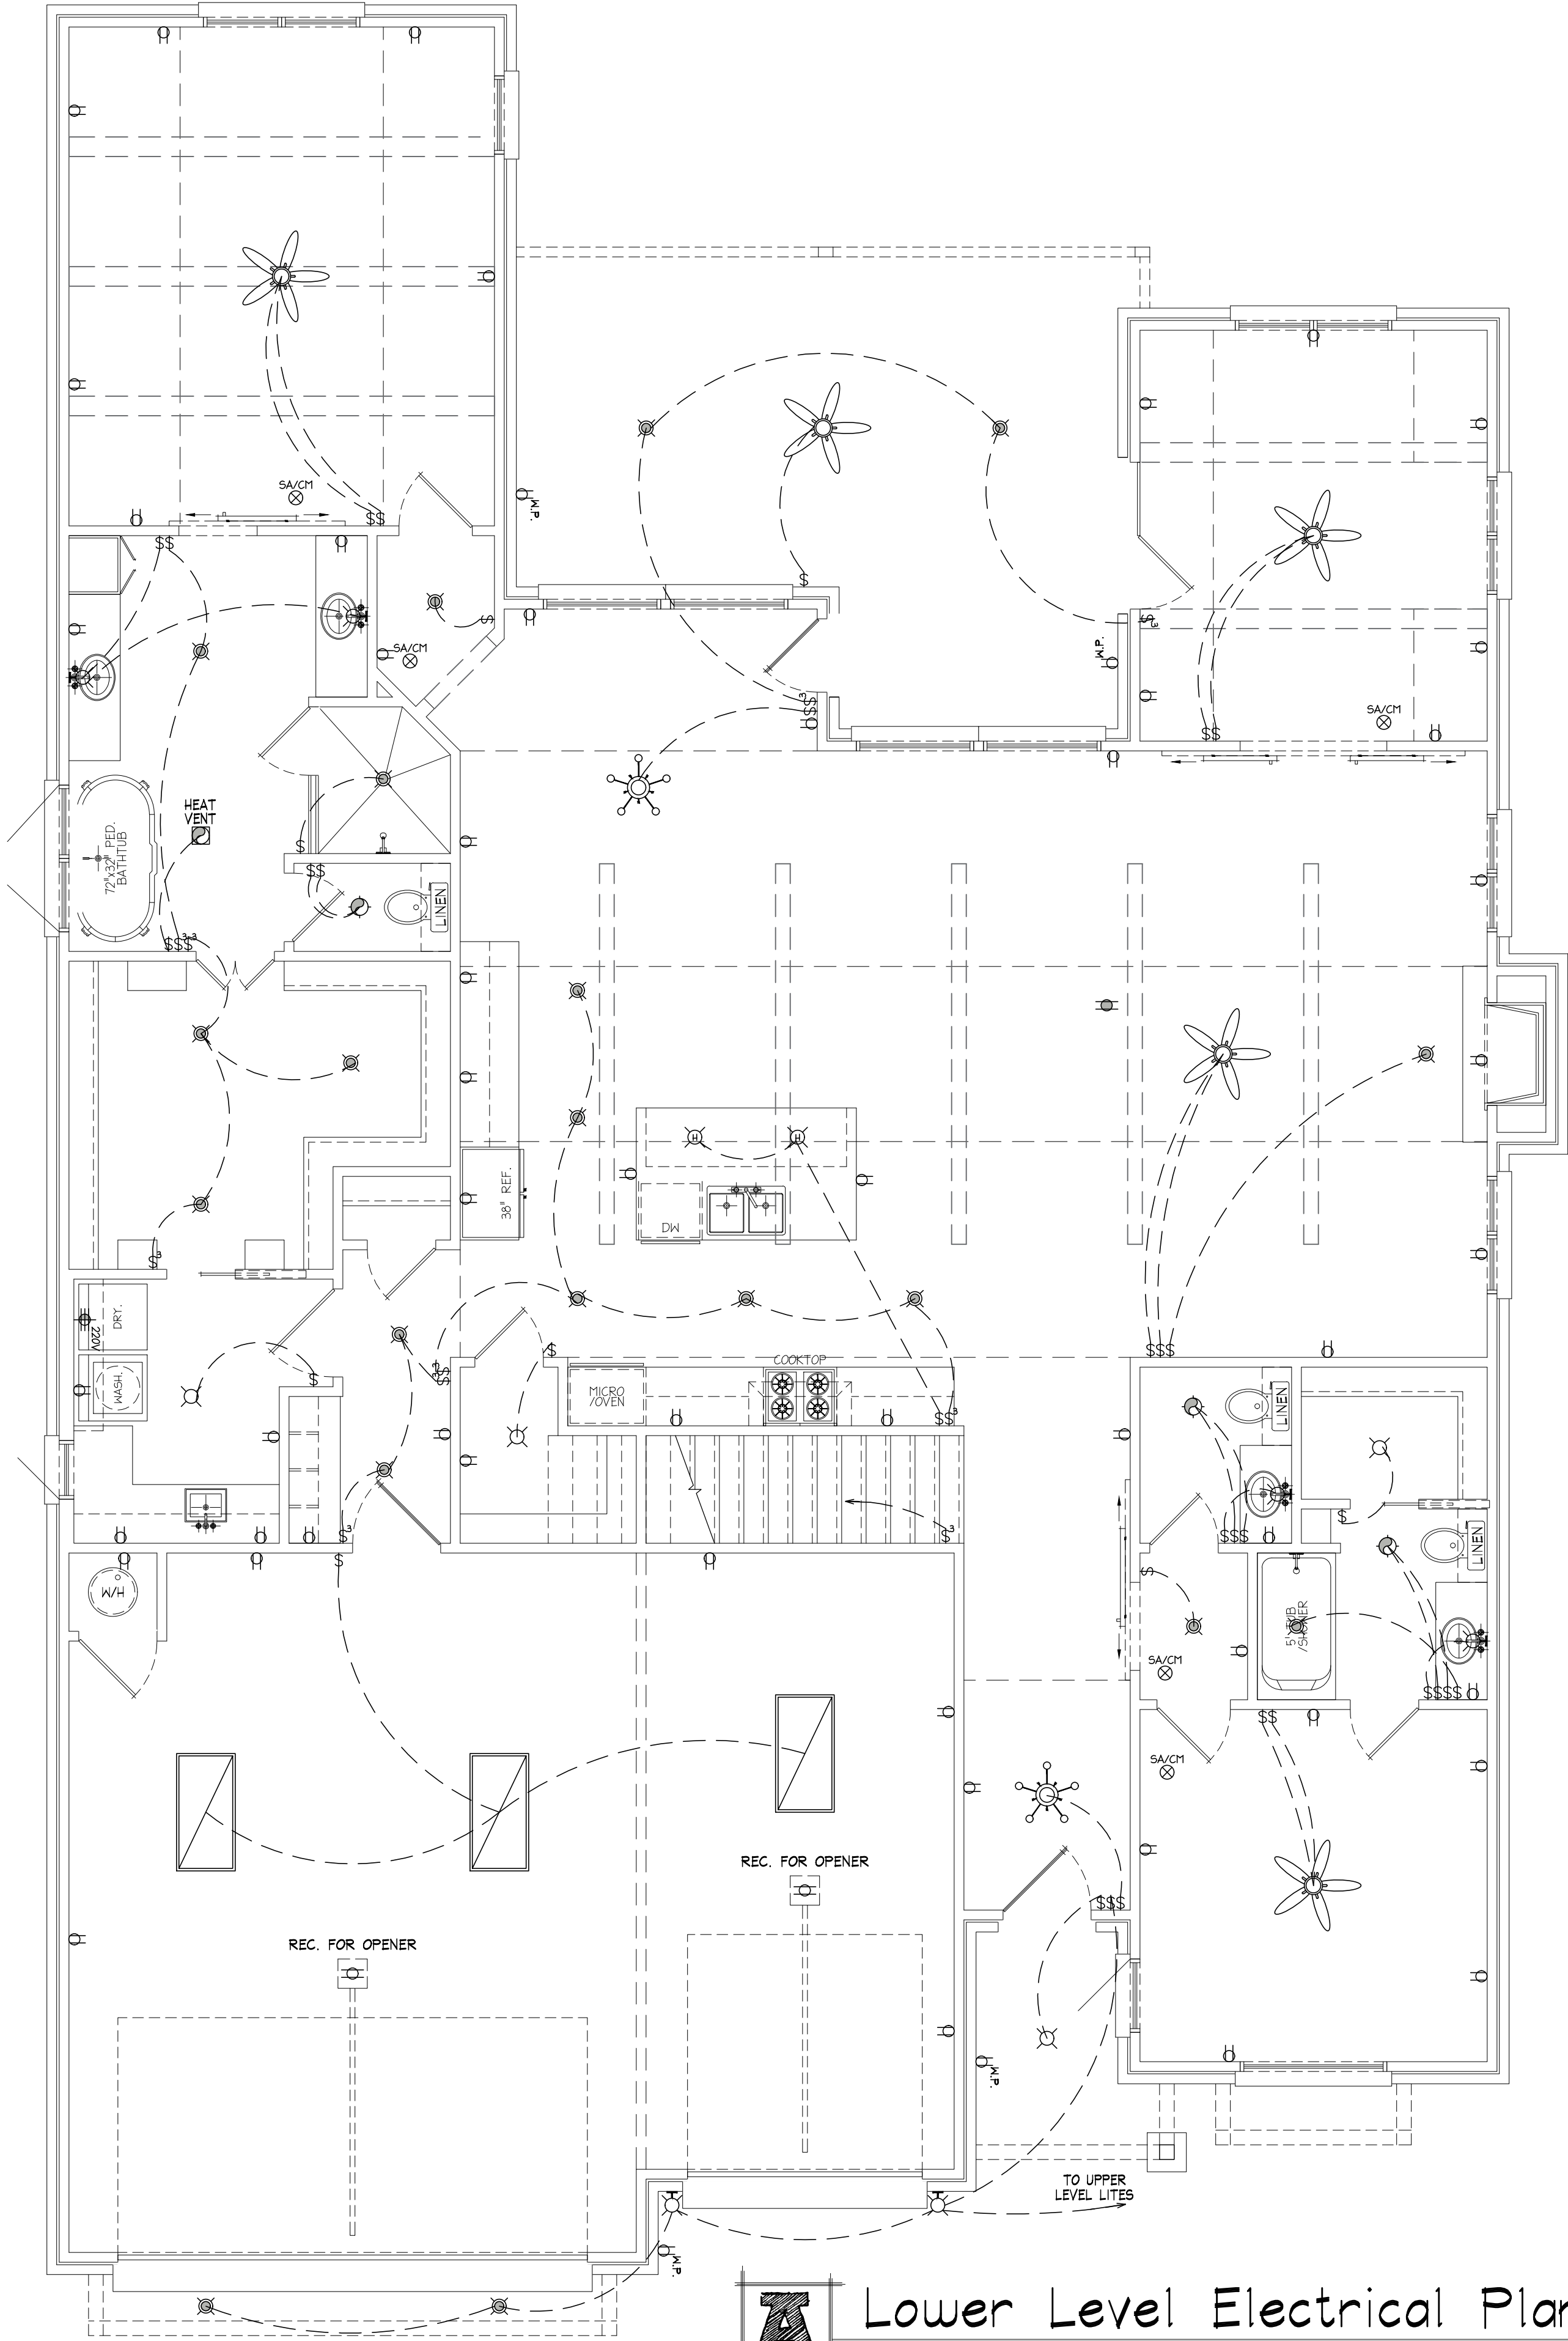

A Lower Level Electrical Plan
Scale: 1/4" = 1'-0"

THIS DRAWING IS A CONCEPT. IT INDICATES THE GENERAL LAYOUT OF THE WORK. IT DOES NOT INDICATE THE EXACT LOCATION OF THE WORK. THE CONTRACTOR IS RESPONSIBLE FOR VERIFYING THE LOCATION OF THE WORK. THE CONTRACTOR IS RESPONSIBLE FOR VERIFYING THE LOCATION OF THE WORK. THE CONTRACTOR IS RESPONSIBLE FOR VERIFYING THE LOCATION OF THE WORK.

Copyright © Bainbridge Design Group
Resale or reproduction of these plans, in part or in whole, is strictly prohibited without written consent.

COZORT
CONSTRUCTION

Project Name:

Location:
Project #: 22.06.03



First: 2270
Second: 1192
Total Living: 3462
Total Veneer: 3598
Garage: 710
Cov'd Porch: 358

Date: 4/21/2022

DRAWING #

E1

**Bainbridge
Design Group**
2723 E. 15th St., Tulsa, OK 74104
918.499.1497

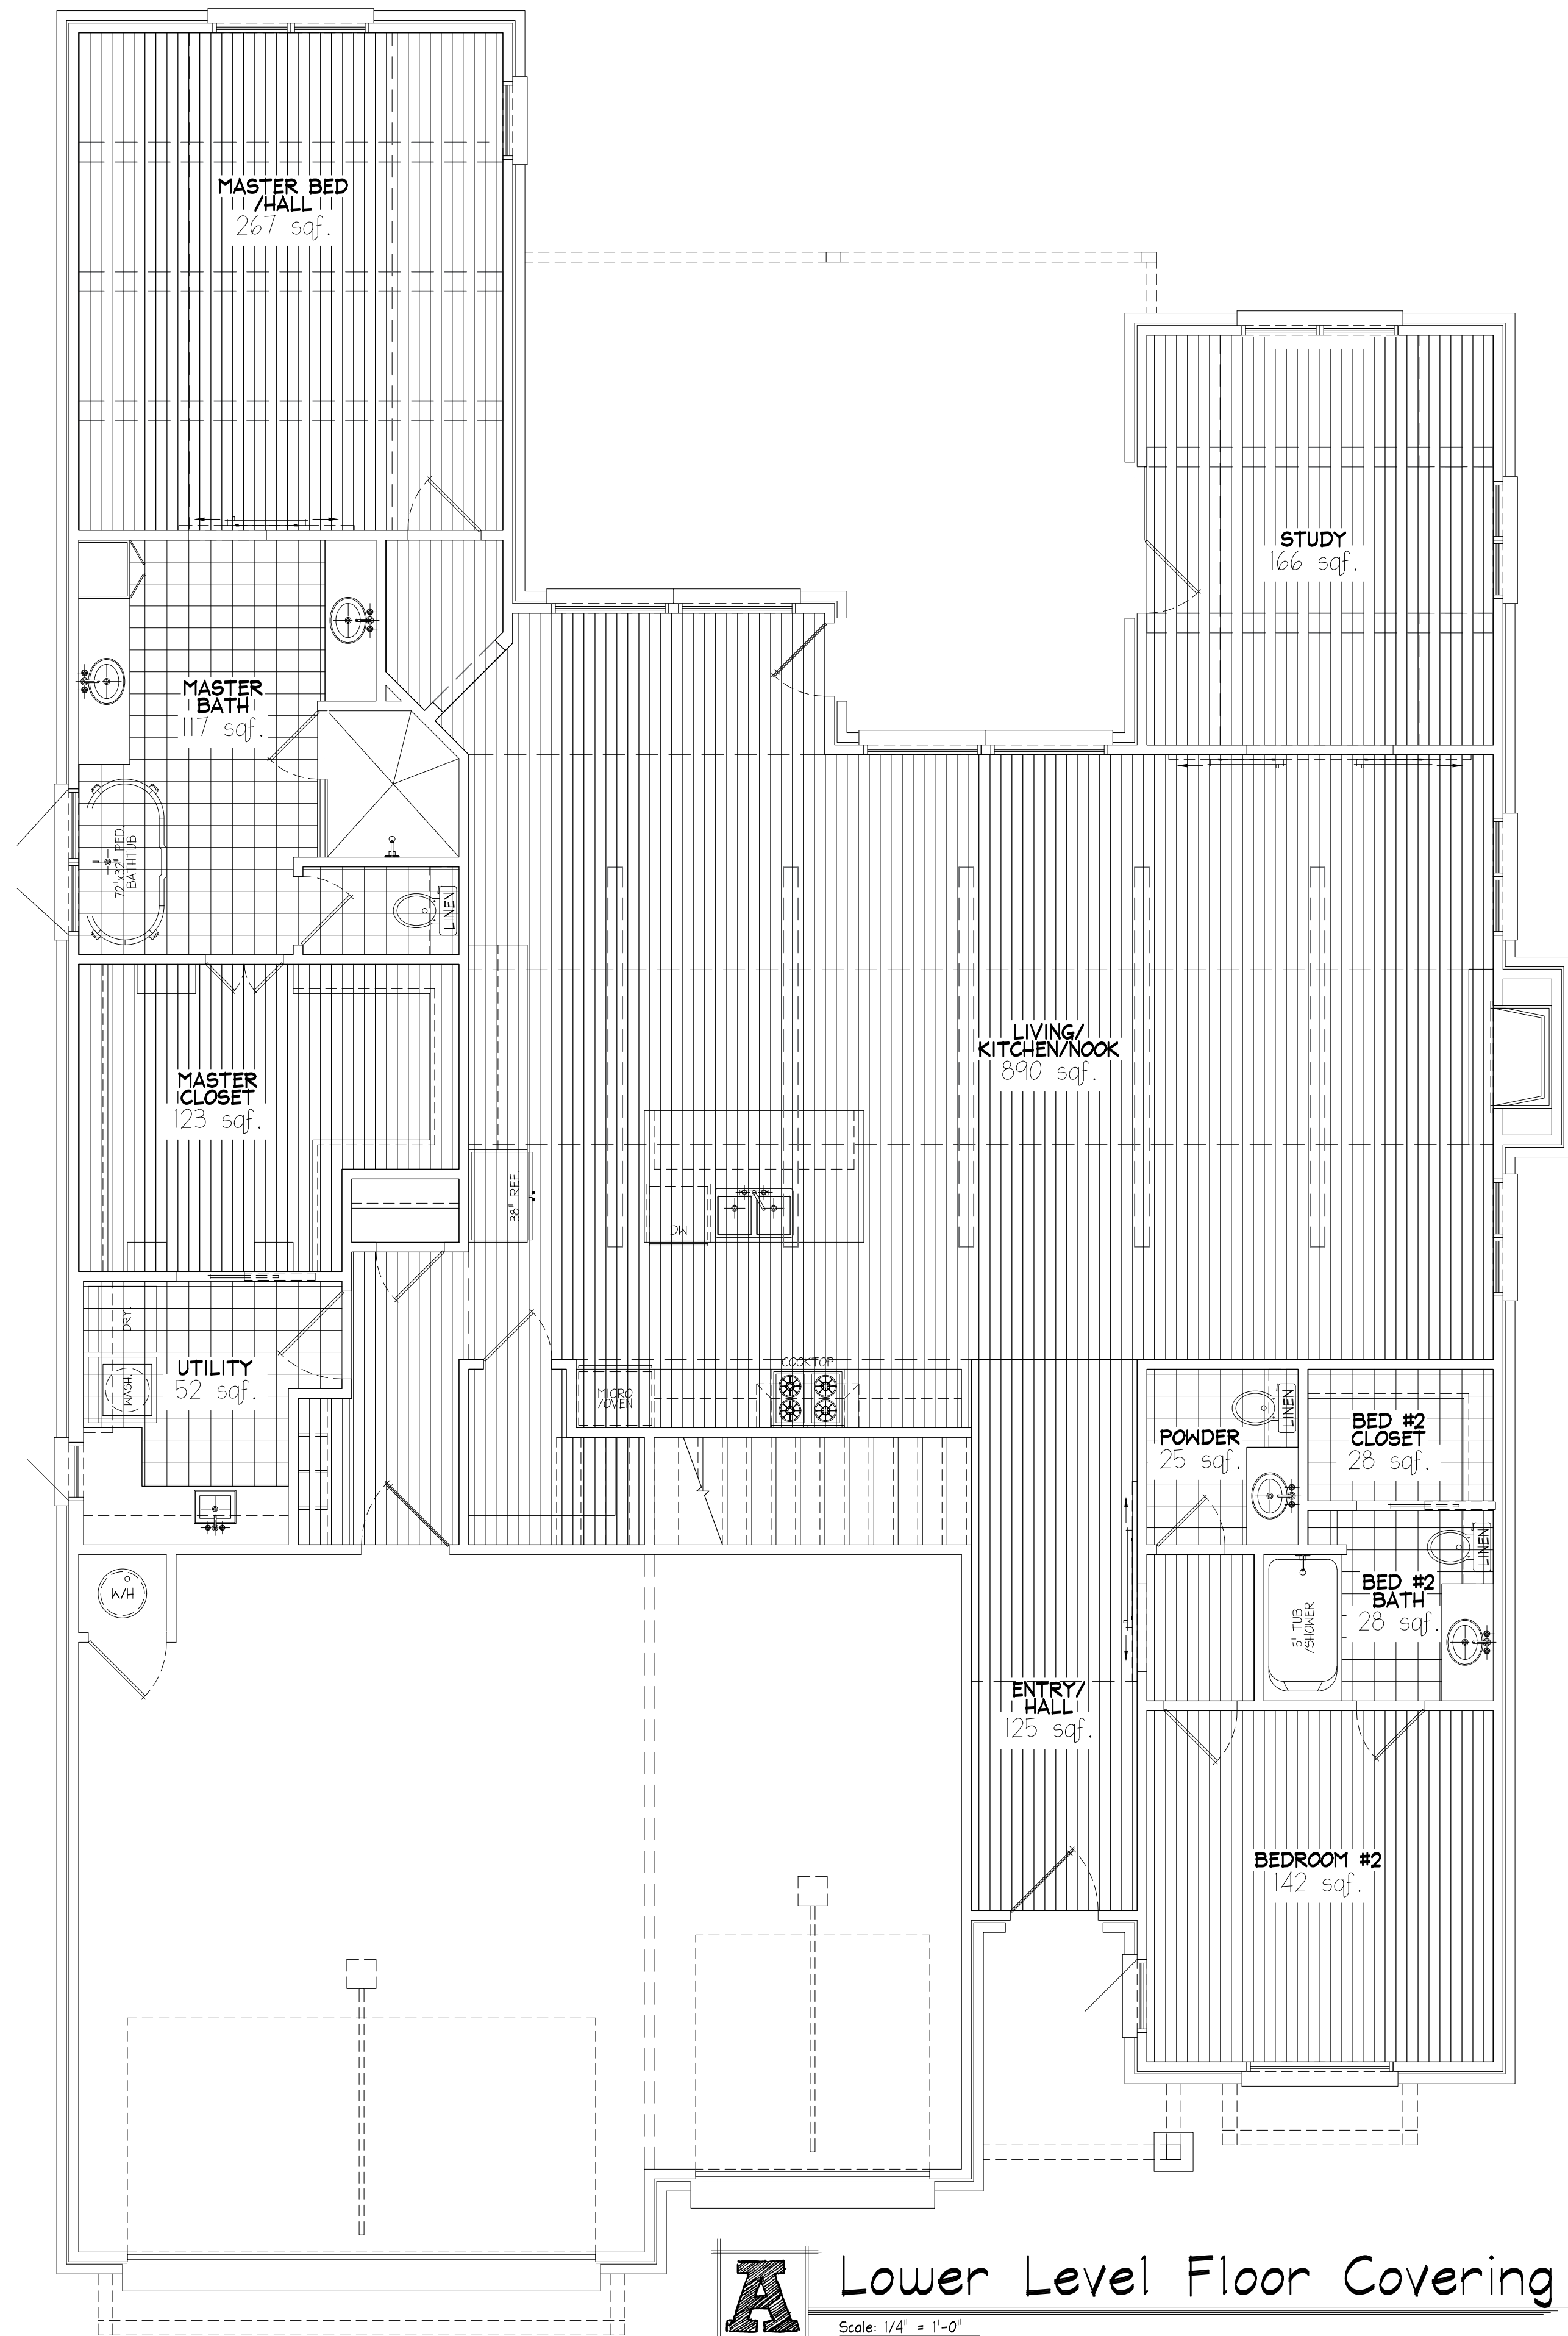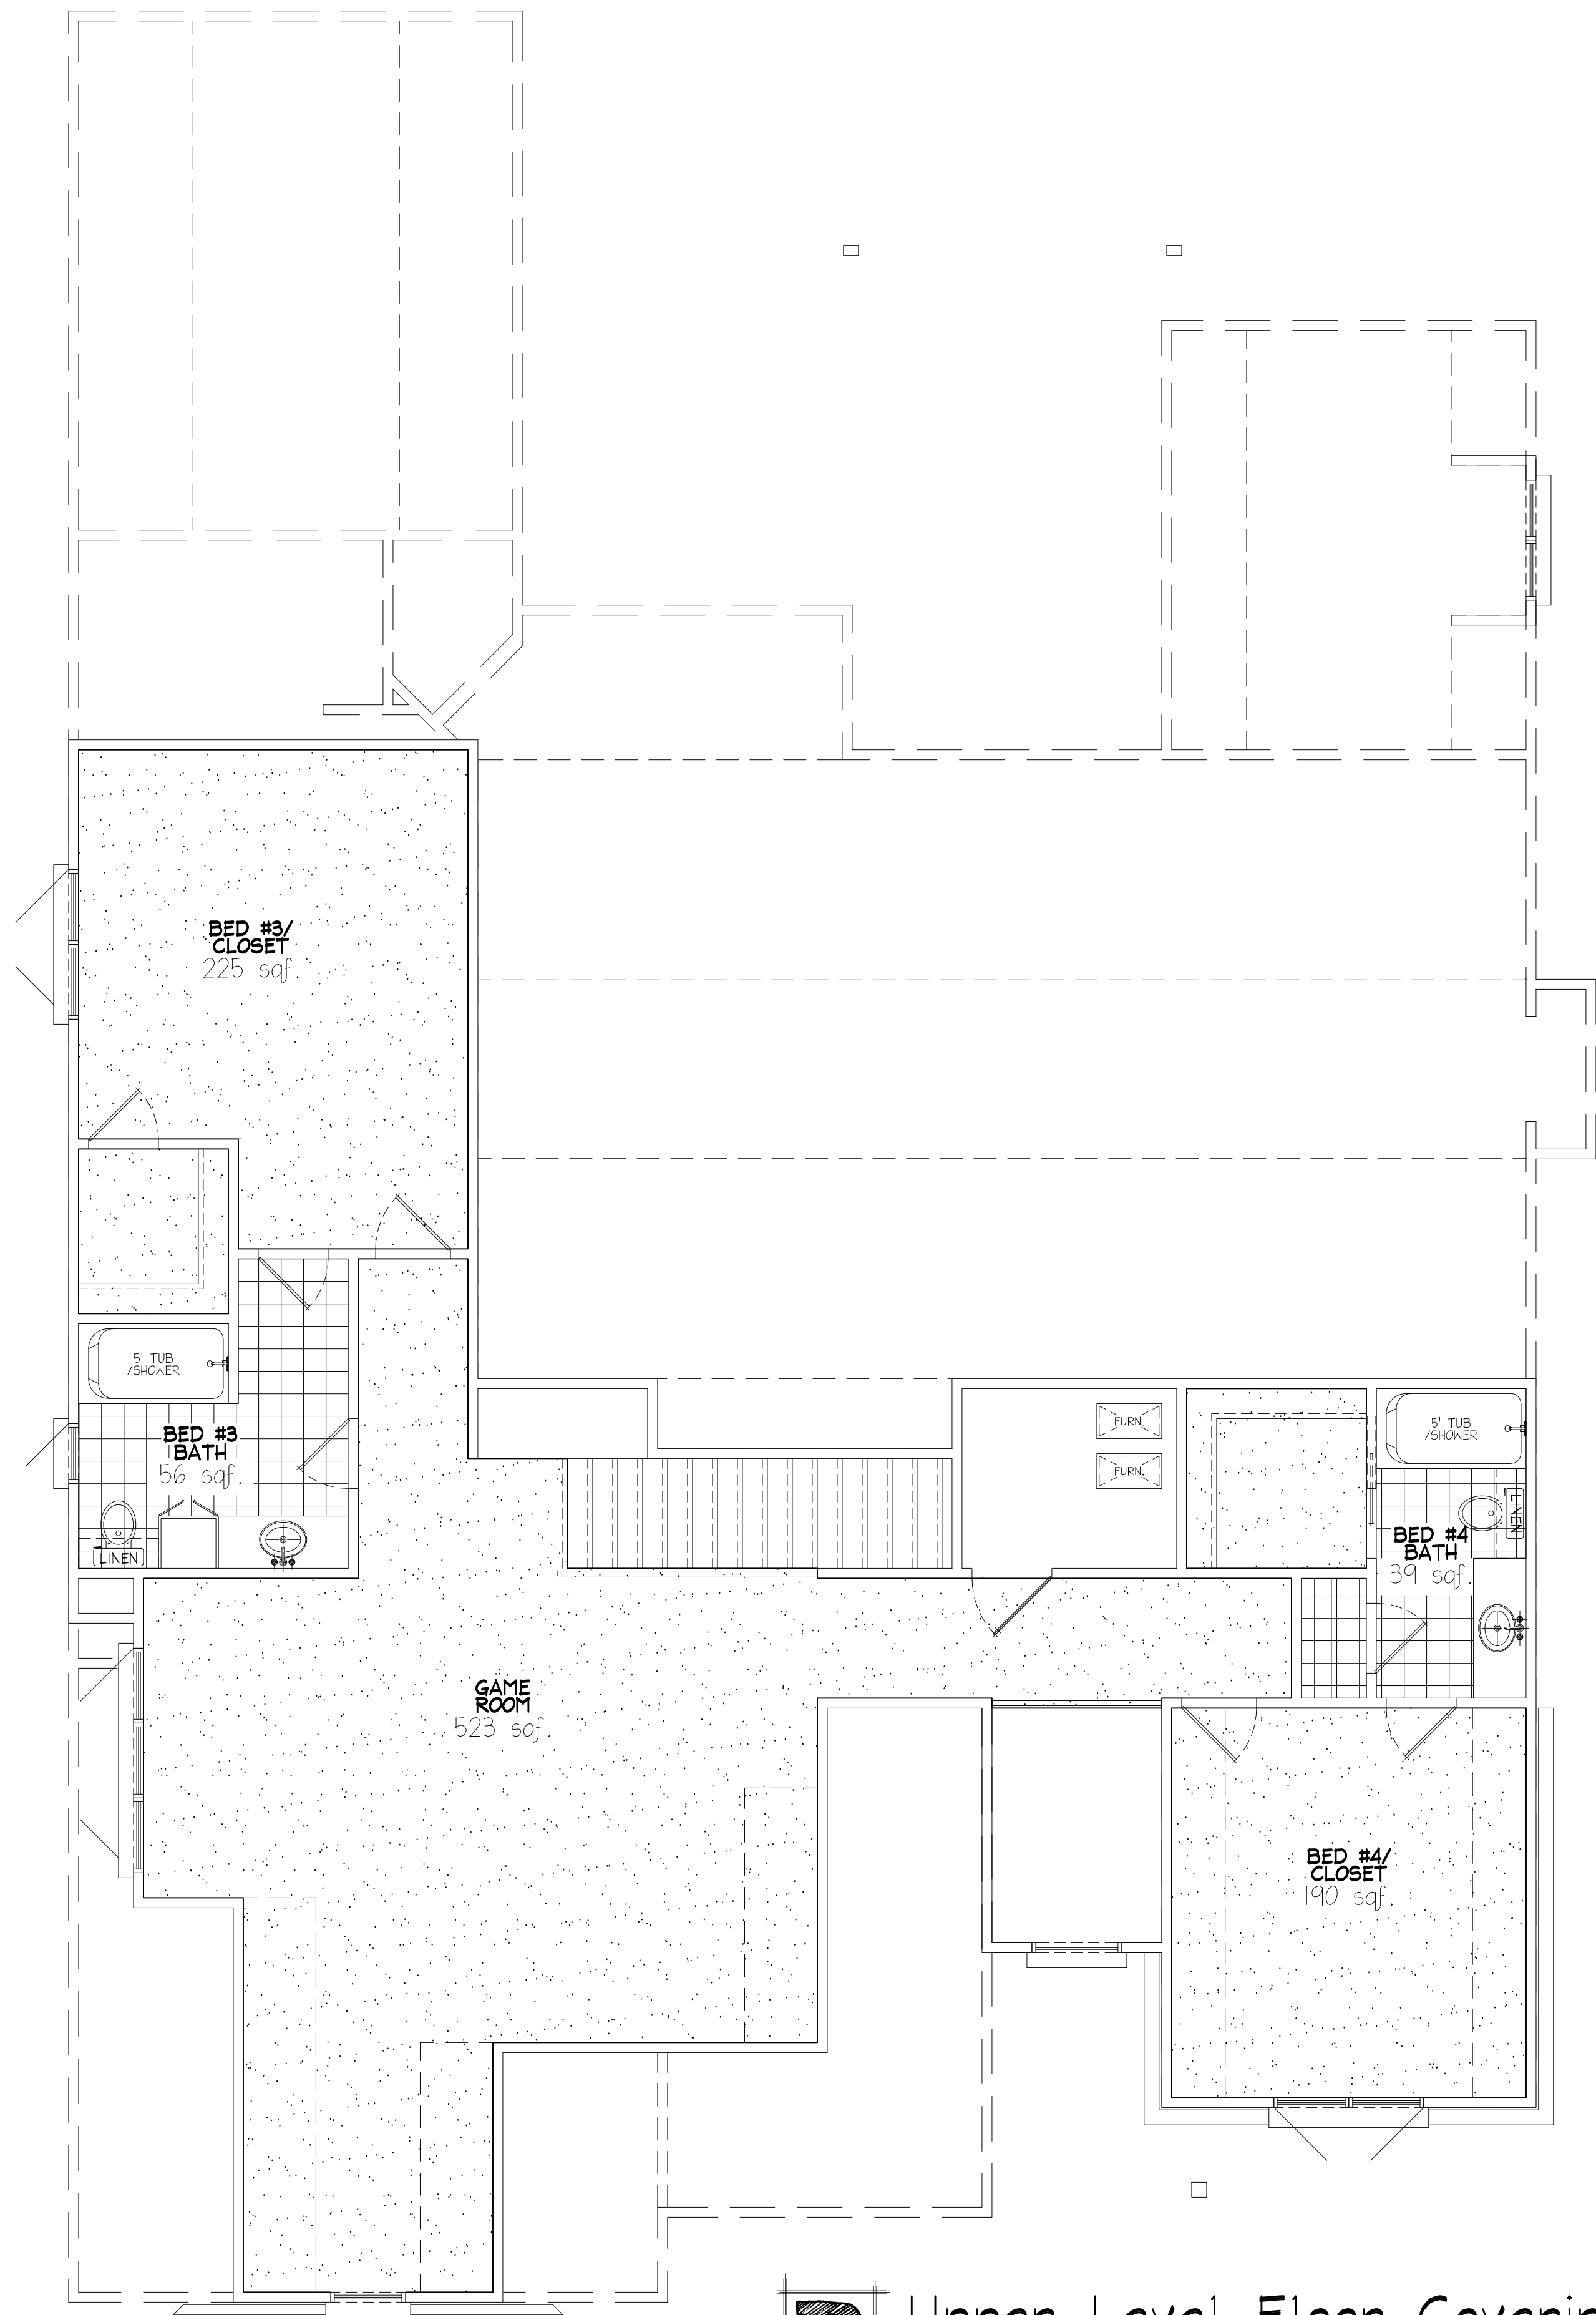

FLOOR COVERING SQF. CALCULATIONS			
TOTAL			
CARPET		938	
TILE		345	
WOOD		1713	
TILE	250	CARPET	938
MASTER BATH	117	BED #4/ CLOSET	190
UTILITY	52	BED #3/ CLOSET	228
POWDER	25	GAME ROOM	523
BED #2 CLOSET	28	TILE	
BED #2 BATH	28	05	
WOOD	1713	BED #3 BATH	56
MASTER CLOSET	123	BED #4 BATH	39
MASTER BED /HALL	267		
STUDY	166		
LIVING/ KITCHEN/NOOK	890		
BEDROOM #2	142		
ENTRY/ HALL	125		

CALCULATION NOTES

- WOOD FLOOR CALCULATED TO WALL FRAMING.
- TILE AND CARPET FLOOR CALCULATED TO CABINETRY.
- TILE SHOWERS (WHERE APPLICABLE) NOT INCLUDED IN CALCULATIONS.

THIS DRAWING AS A CONCEPT INDICATES THE GENERAL LAYOUT OF THE PROPOSED CONSTRUCTION. IT DOES NOT INDICATE OR DESCRIBE ALL REQUIREMENTS FOR COMPLETION OF THE WORK. THE CONTRACTOR IS RESPONSIBLE FOR OBTAINING ALL NECESSARY PERMITS, CONSTRUCTION, CONFIRMING DETAILS, ACCURACY OF THE WORK, DIMENSIONS AND CONDITIONS TO BE SHOWN AND CORRELATED AT THE JOB SITE.

Copyright © Bainbridge Design Group
Resale or reproduction of these plans, in part or in whole, is strictly prohibited without written consent.

COZORT
CONSTRUCTION

Project Name:

Location:

Project #: 22.06.03

First: 2270
Second: 1192
Total Living: 3462
Total Veneer: 3598
Garage: 710
Cov'd Porch: 358

Date: 4/21/2022

DRAWING #

FC1



THIS DRAWING AS A CONCEPT INDICATES THE GENERAL SCOPE OF THE PROJECT. IT DOES NOT NECESSARILY INDICATE OR DESCRIBE ALL REQUIREMENTS FOR COMPLETION OF THE WORK. THE CONTRACTOR IS SOLELY RESPONSIBLE FOR TECHNIQUES OF CONSTRUCTION, CONFIRMING DETAILS, ACCURACY OF THE WORK, DIMENSIONS AND CONDITIONS TO BE CONFIRMED AND CORRELATED AT THE JOB SITE.

Copyright © Bainbridge Design Group
Resale or reproduction of these plans, in part or in whole, is strictly prohibited without written consent.

COZORT
CONSTRUCTION

Project Name:

Location:	
Project #:	22.06.03

First:	2270
Second:	1192
Total Living:	3462
Total Veneer:	3598
Garage:	710
Cov'd Porch:	358

Date: 4/21/2022

DRAWING #

S1